



1 Master Suite
Scale: 1/2" = 1'-0"

<p>Designer/Contact Information: Ron Collins Designs Austin, TX</p>	<p>Drawn By: Ron Collins Revision Date:</p>
<p>NOTES:</p>	
<p>Project: Master Suite</p>	
<p>Producer: Ron Collins Purpose: 2D Groundplan</p>	
<p>Date: 11/12/20</p>	
<p>Scale: 1:24</p>	
<p>Sheet: [1] OF 9</p>	

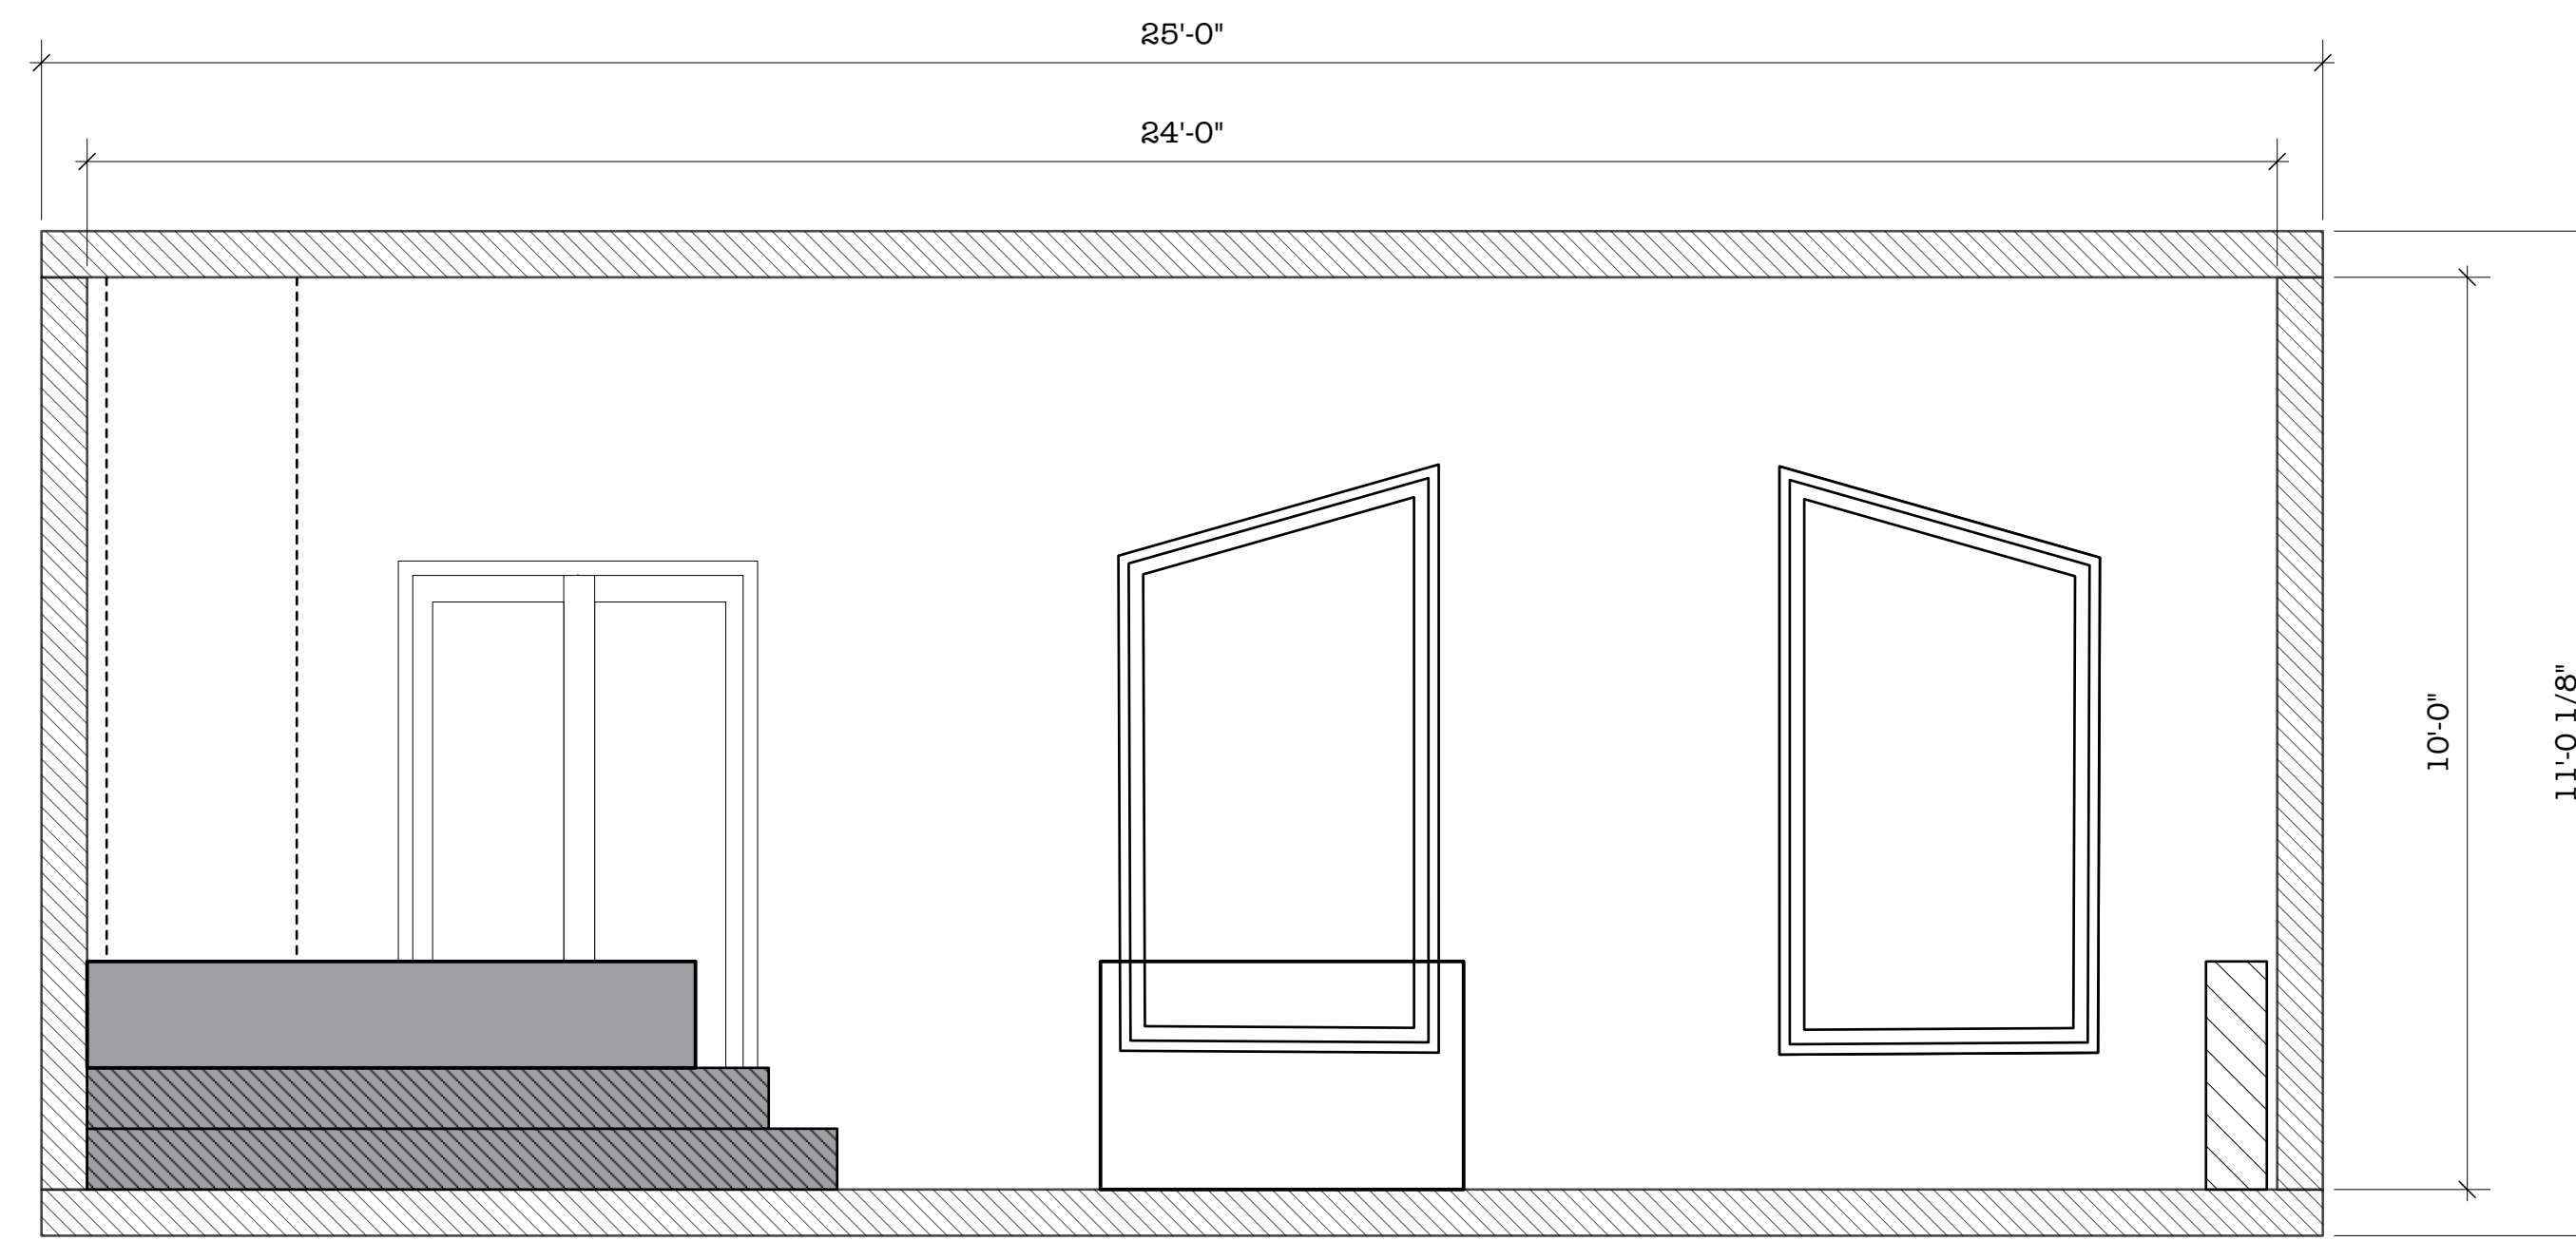

1 Scale: 1/2" = 1'-0"
Section View West

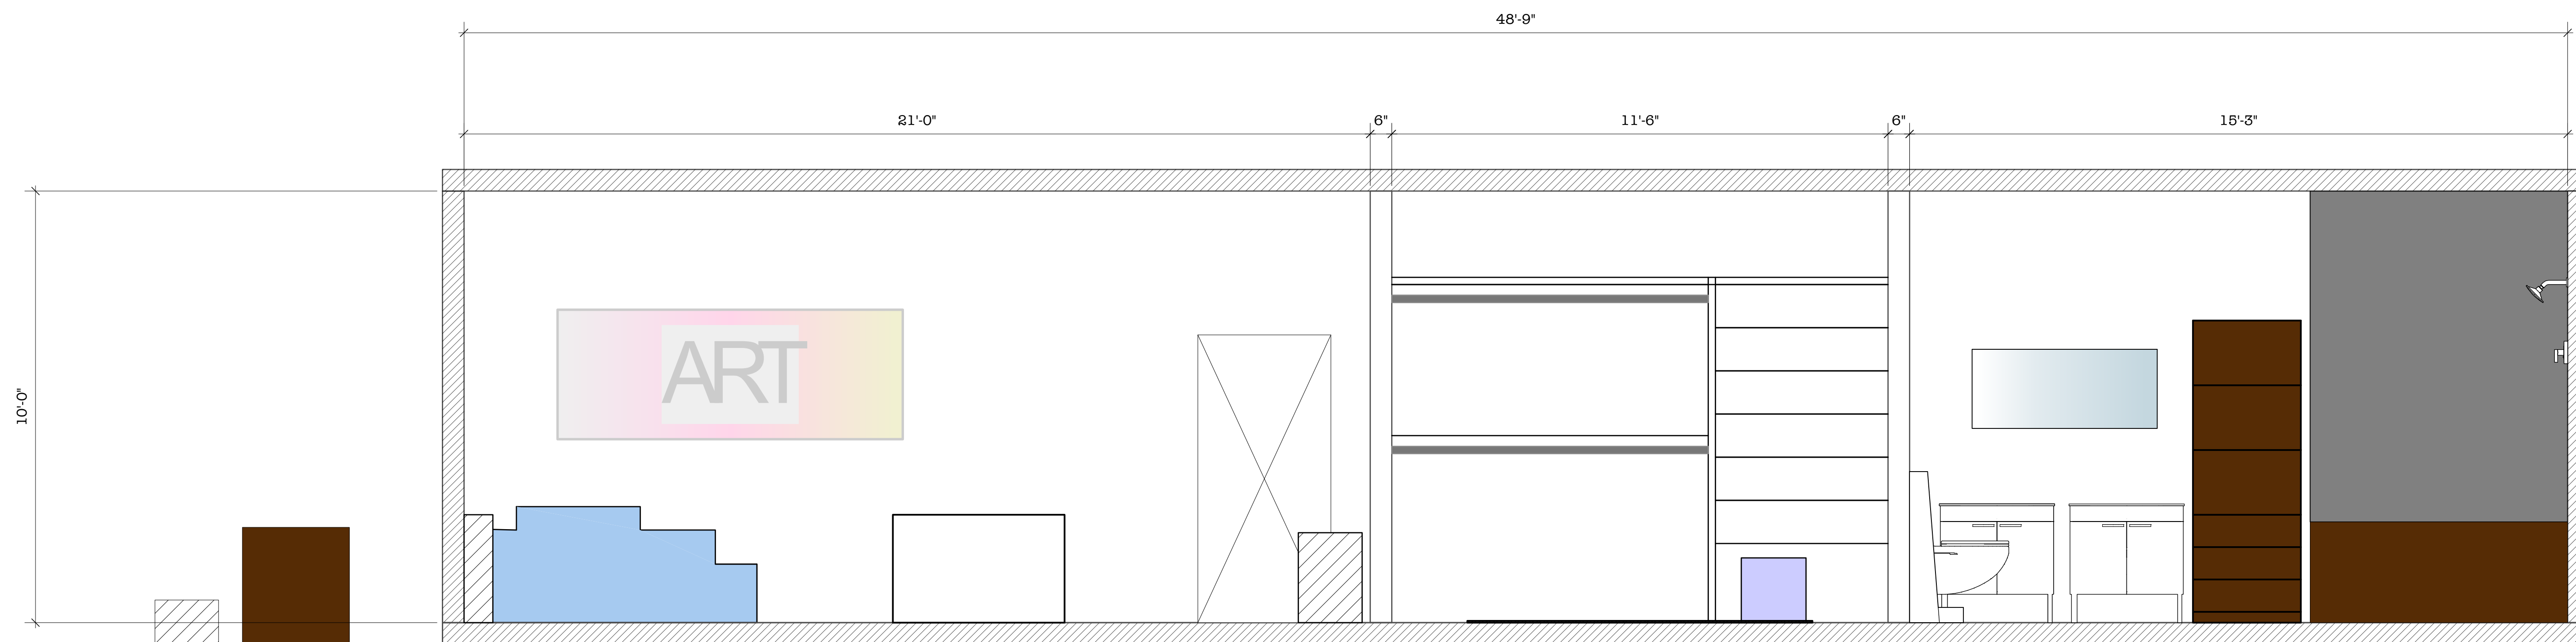

2 Section View (North)
Scale: 1/2" = 1'-0"

Designer/Contact Information:
Ron Collins Designs
Austin, TX

Drawn By:
Revision Date:

NOTES:


Project: **Master Suite**

Producer:
Purpose: **Section View**


Date: 11/23/20

Scale: 1:24


Sheet: **[2]**
OF
9

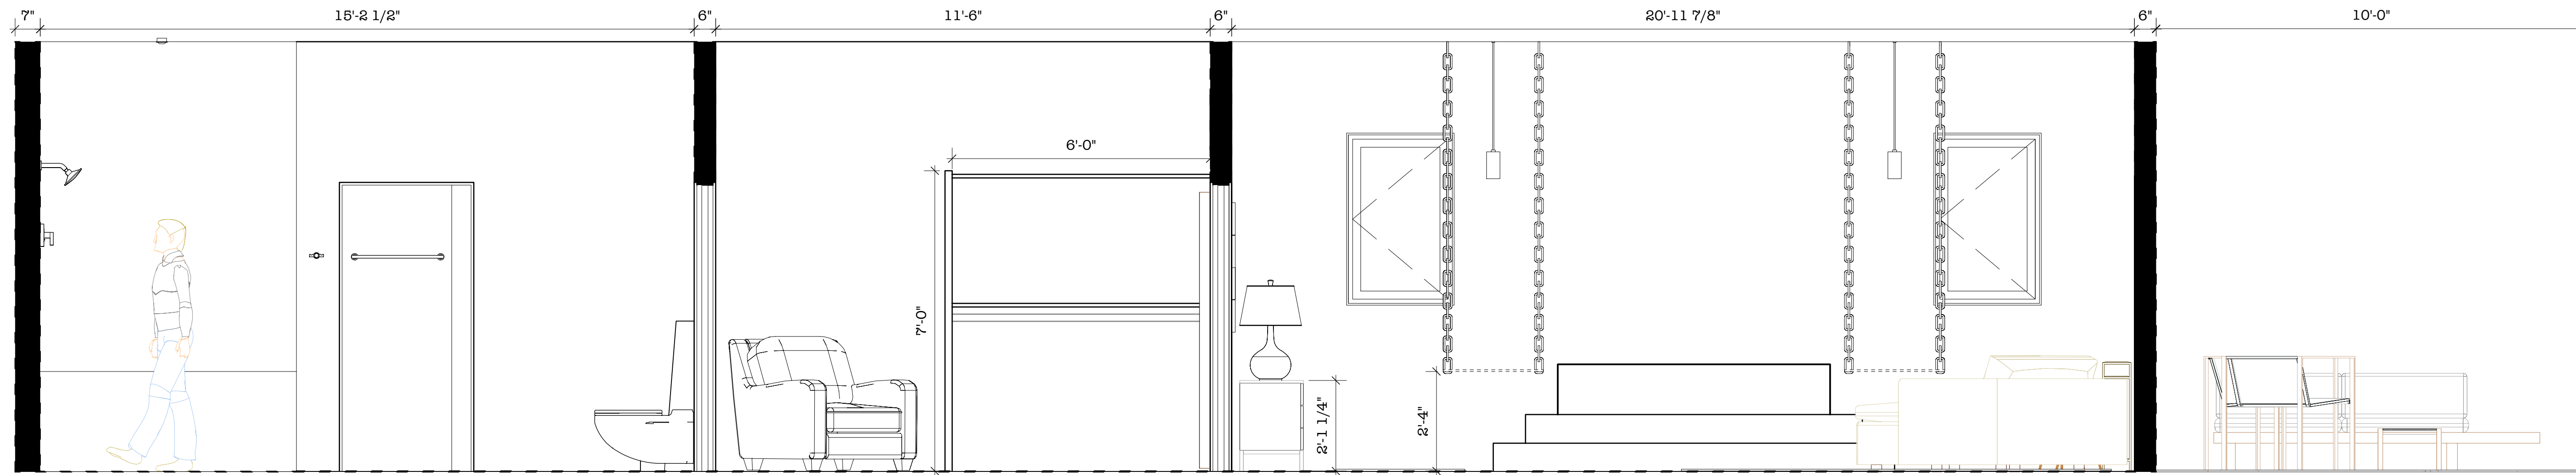


1 Full Suite Facing South
Scale: 1/2" = 1'-0"

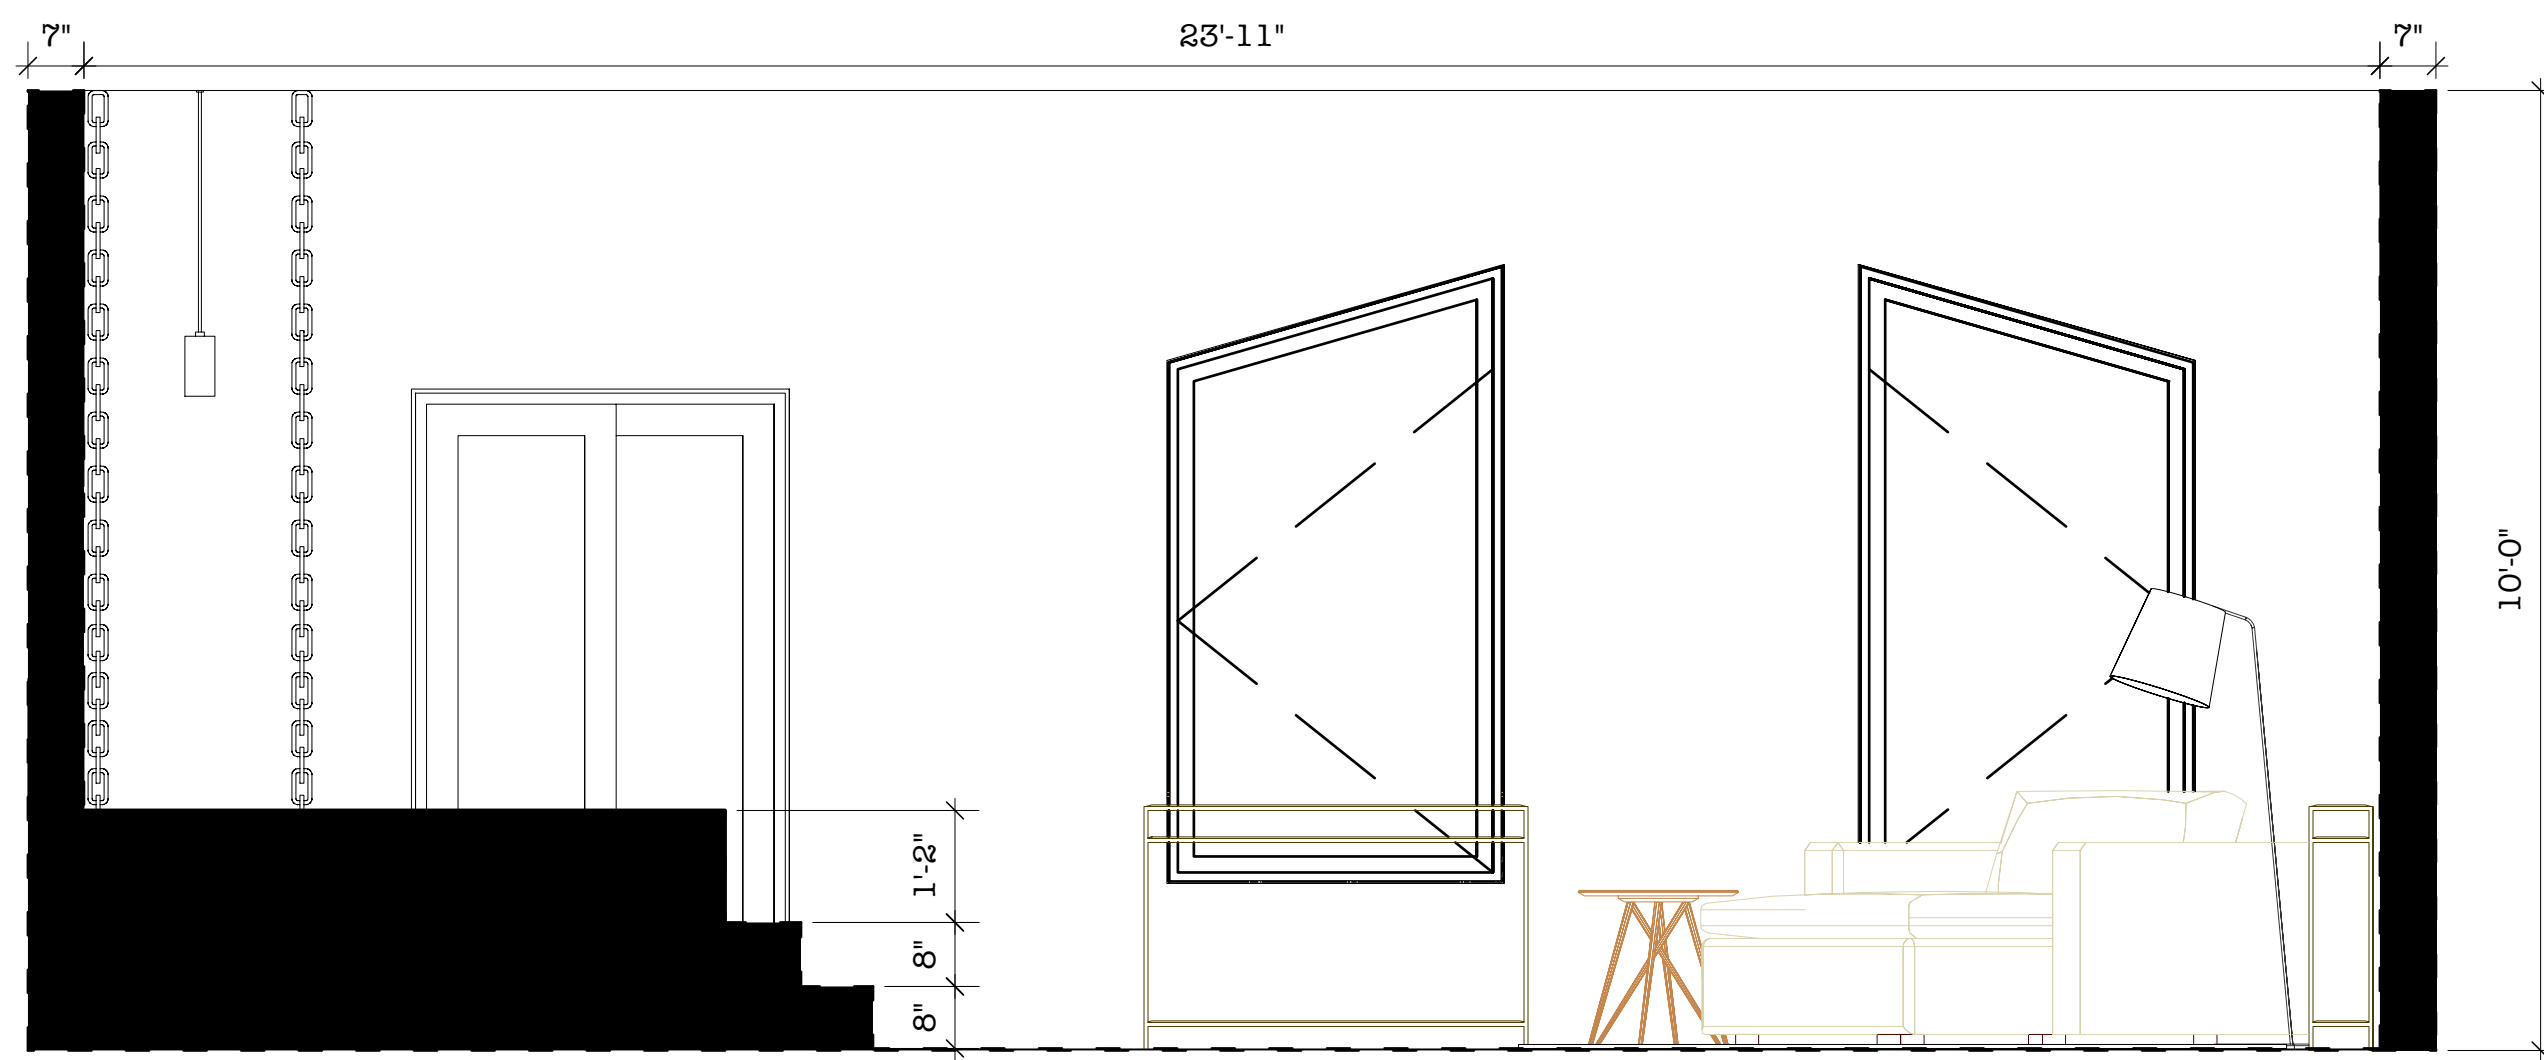

2 Bedroom West
Scale: 1/2" = 1'-0"

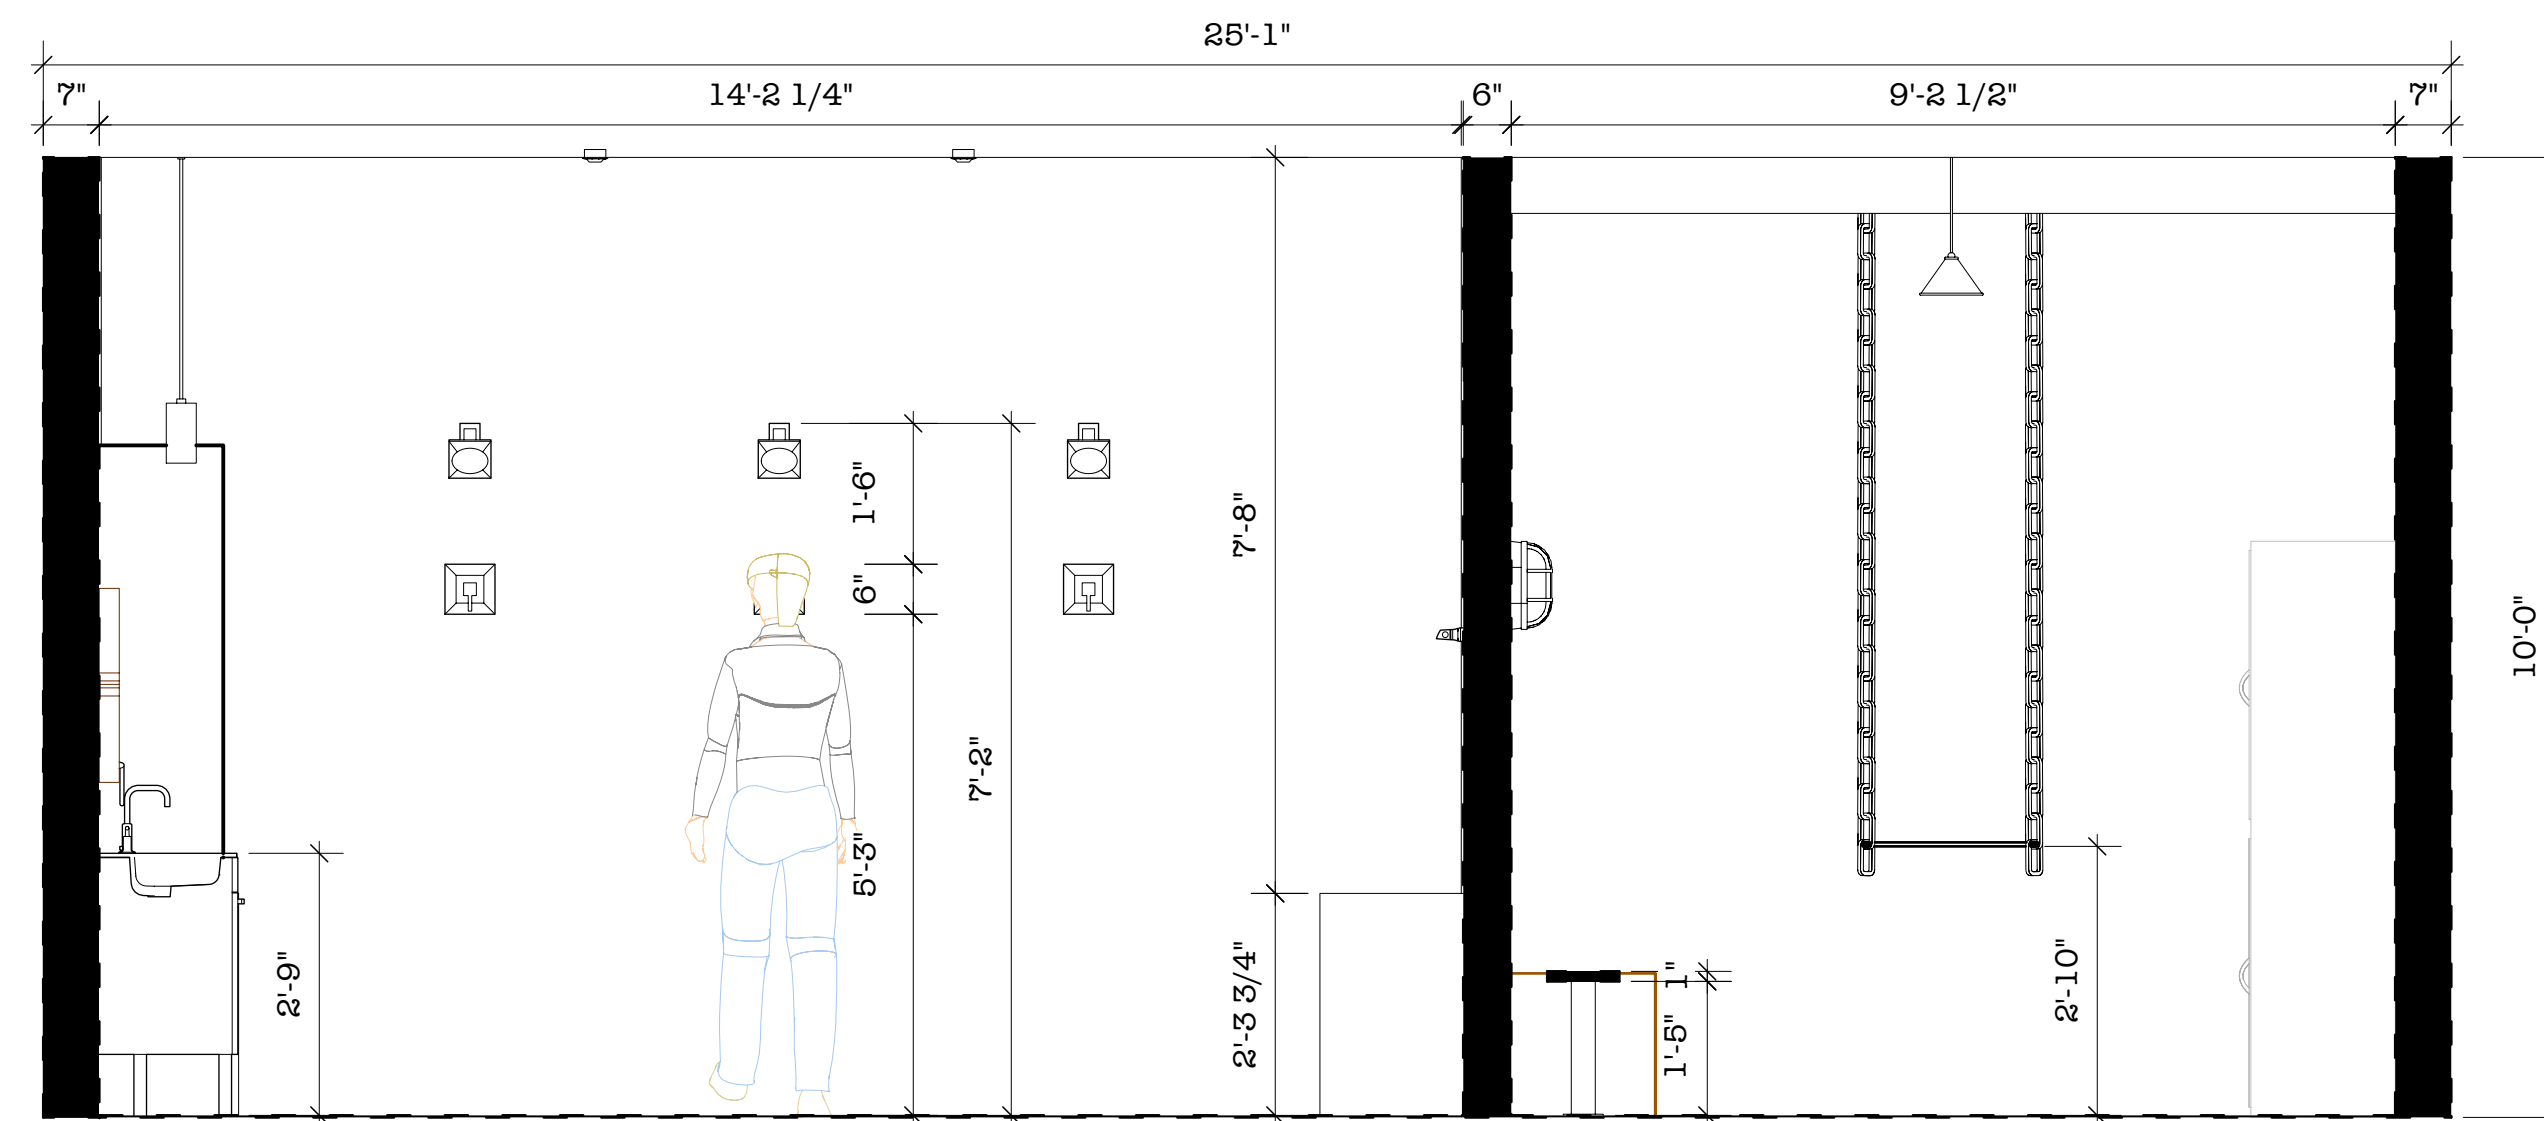

3 Ensuite and Playroom East
Scale: 1/2" = 1'-0"

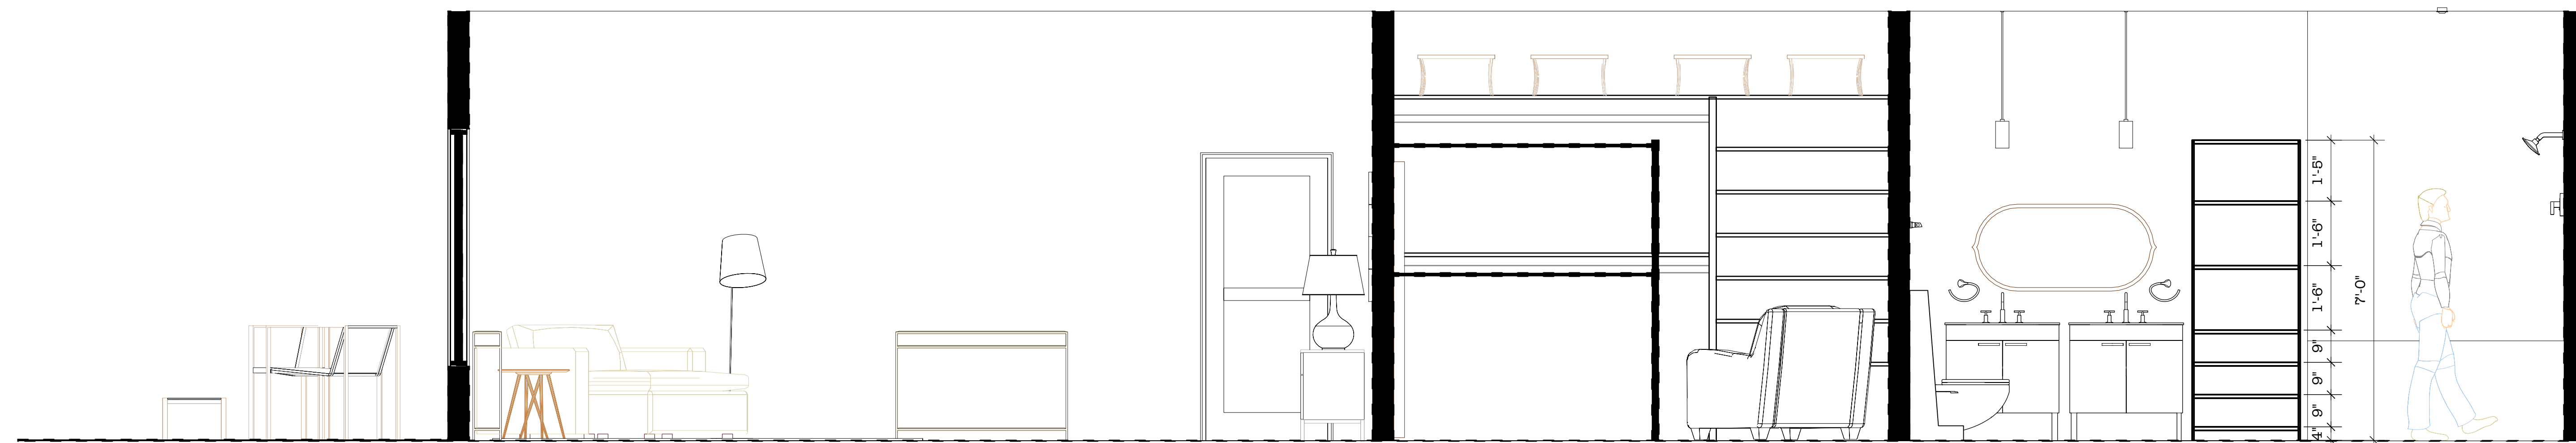

4 Suite North
Scale: 1/2" = 1'-0"

Designer/Contact Information:
Ron Collins Designs
Austin, TX

Drawn By:
Revision Date:


NOTES:

Master Suite

Section Views

Project:
Date: 12/15/20
Scale: 1:24
Sheet:

[3]
OF
9

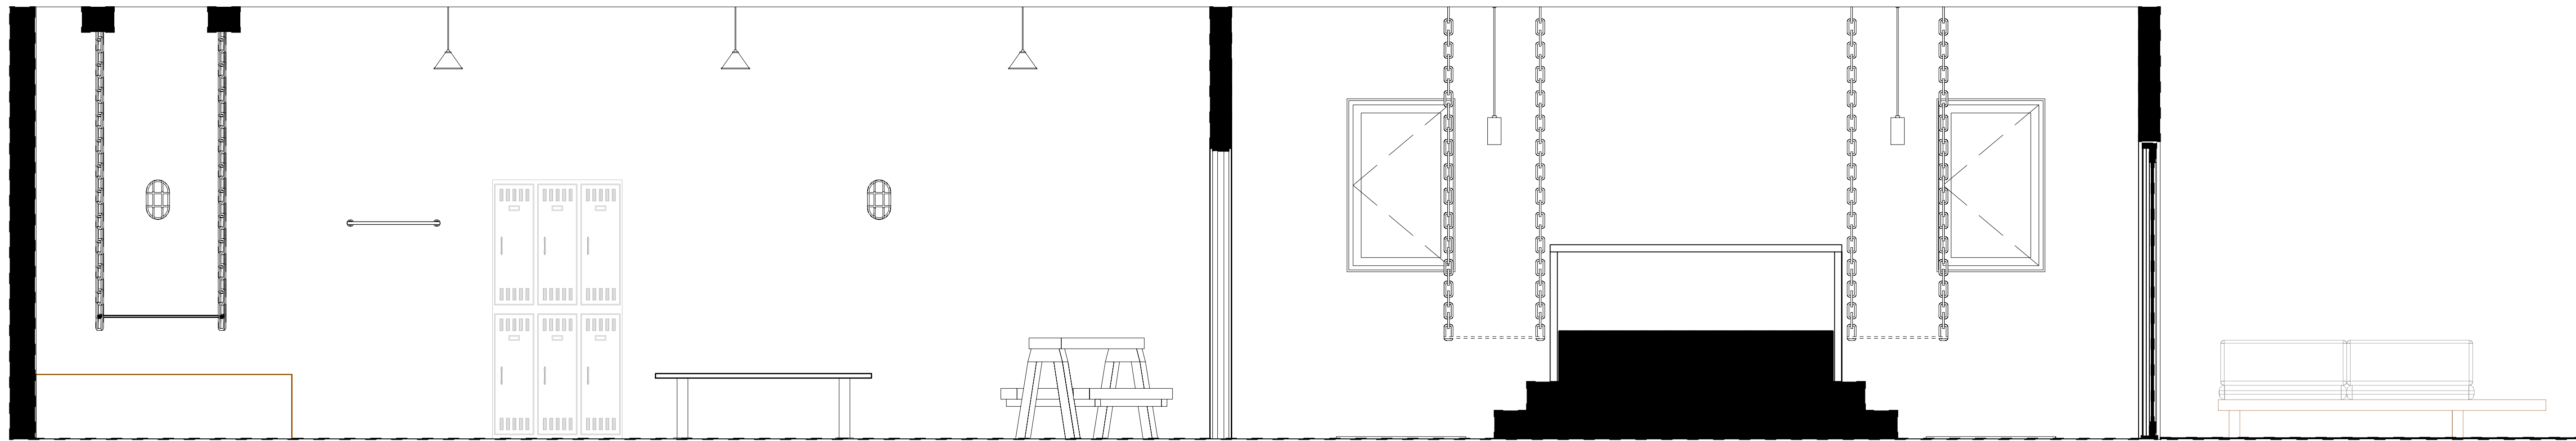

1 Suite Facing South
Scale: 1/2" = 1'-0"



2 Playroom Perspective
Scale: 1/2" = 1'-0"



3 Playroom Perspective Opposite
Scale: 1/2" = 1'-0"



4 Bedroom Perspective
Scale: 1/2" = 1'-0"



5 Off Suite Patio
Scale: 1/4" = 1'-0"

Designer/Contact Information:
Ron Collins Designs
Austin, TX

Drawn By:
Revision Date:

NOTES:

Master Suite

Project:

Date:

12/16/20

Scale:

1:24

Sheet:


[4]
OF

9


Producer:

Purpose:


Section and Perspective Drawings

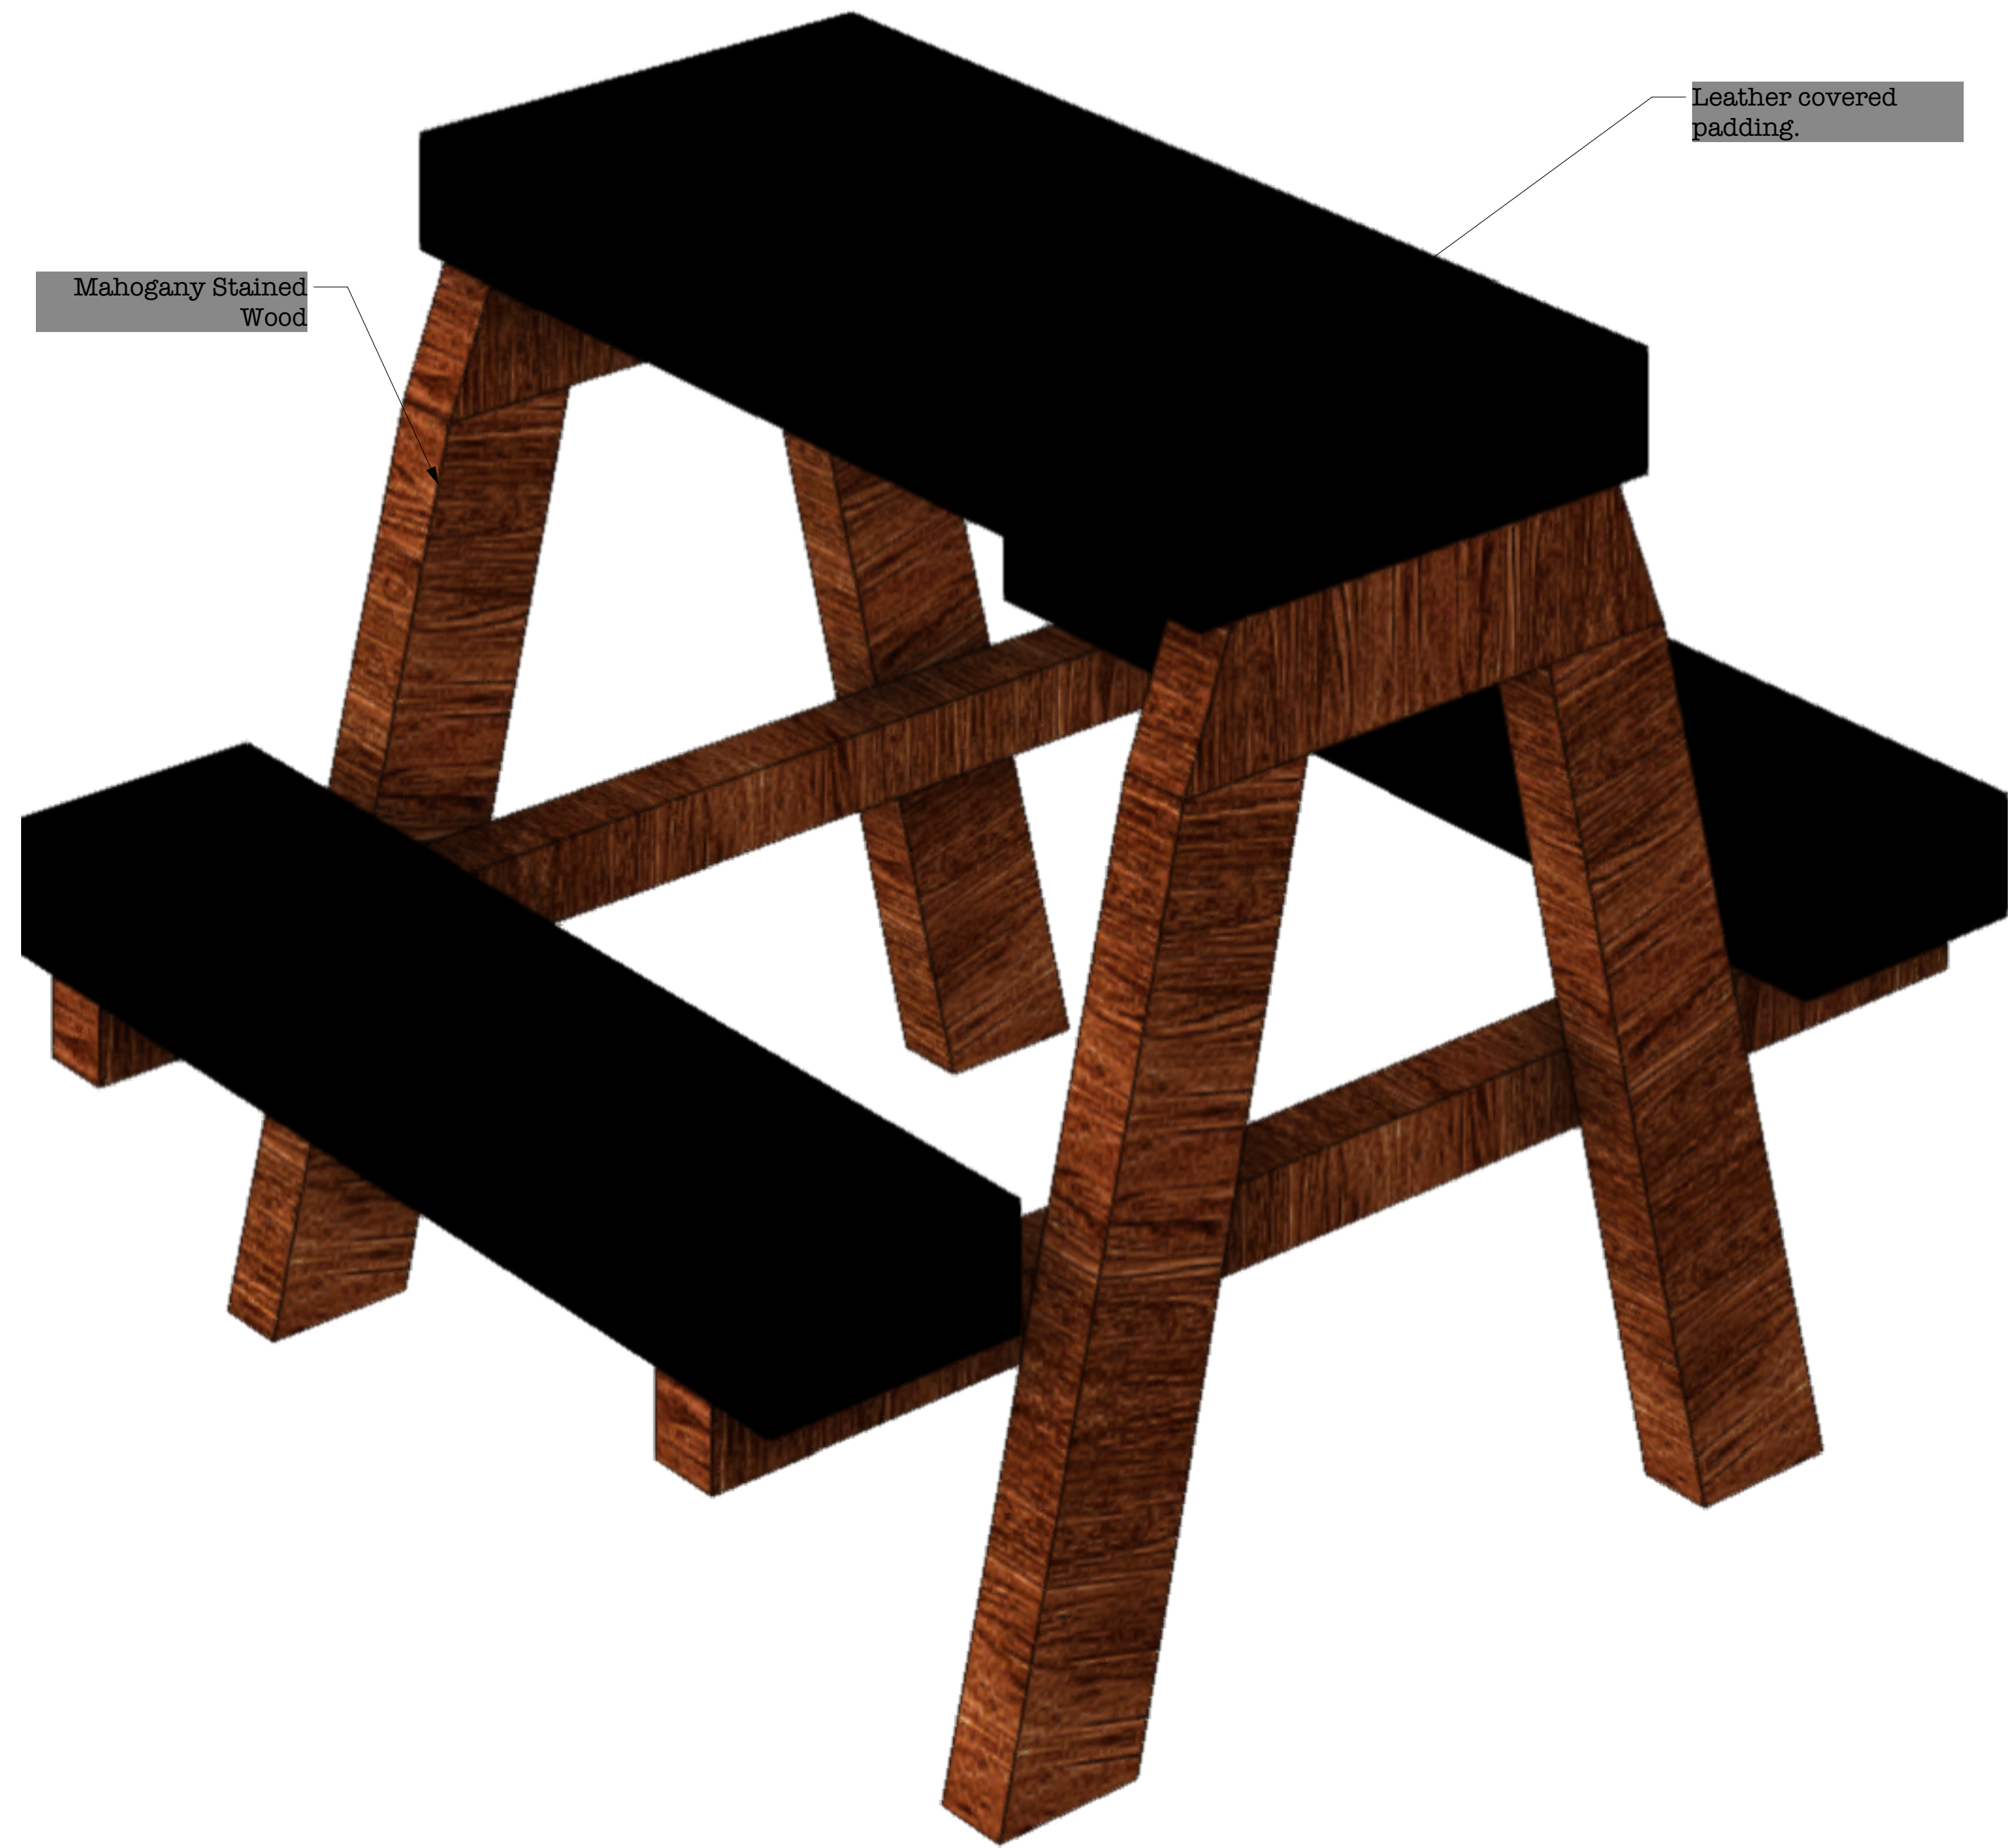


1 Right-Open GL
Scale: 3" = 1'-0"

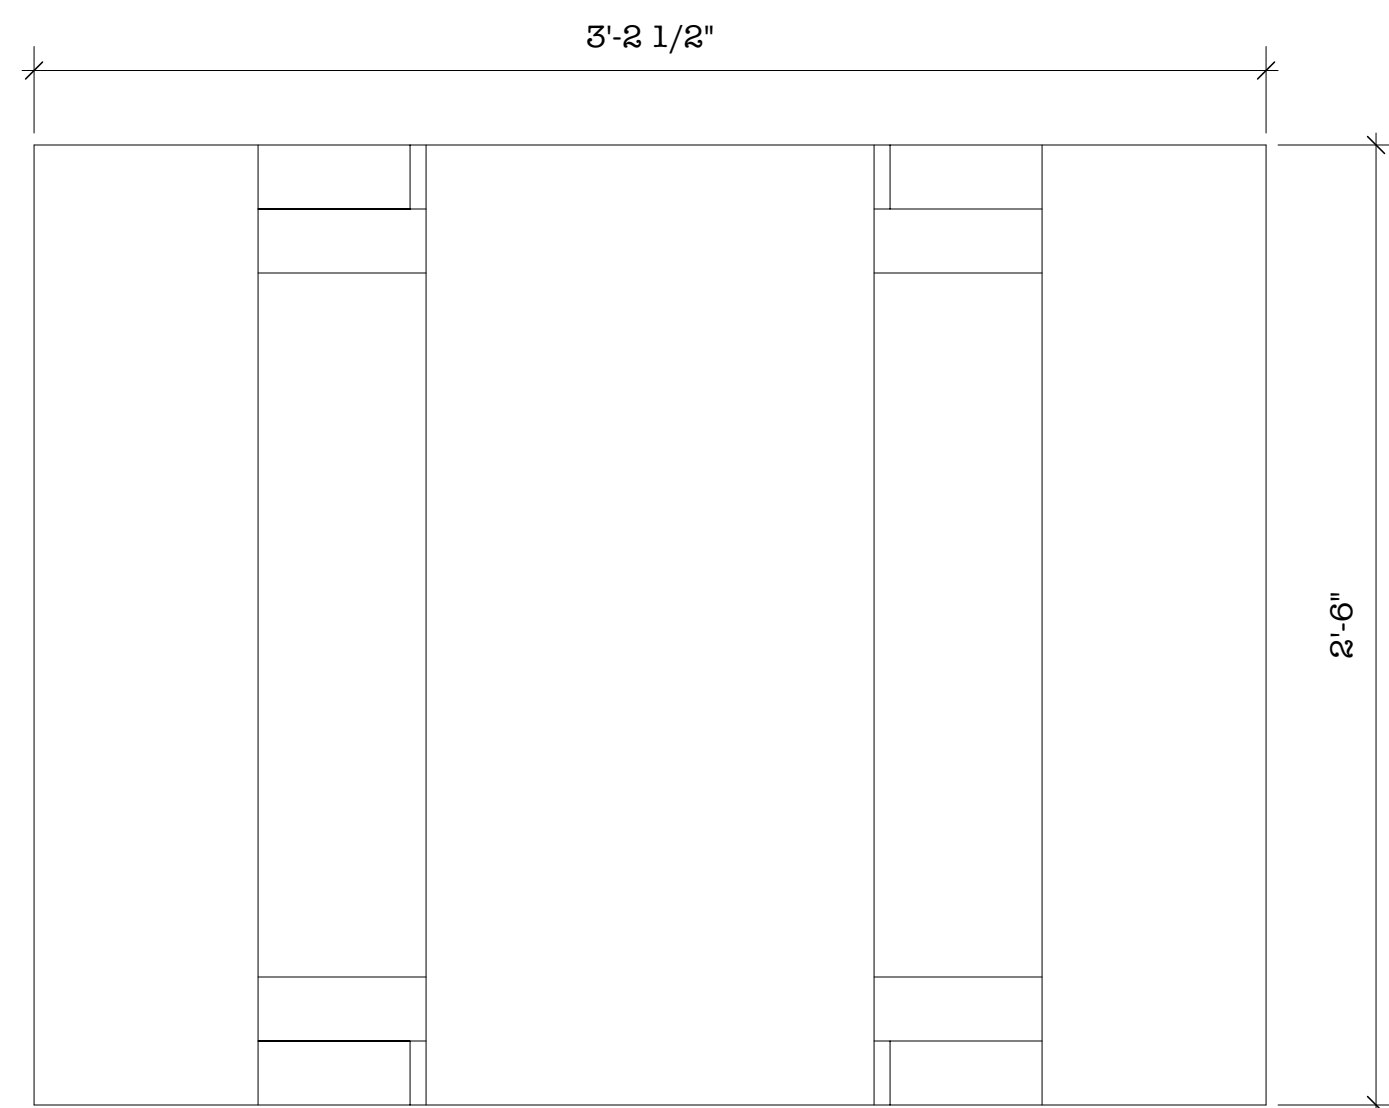

2 Top/Plan
Scale: 2" = 1'-0"

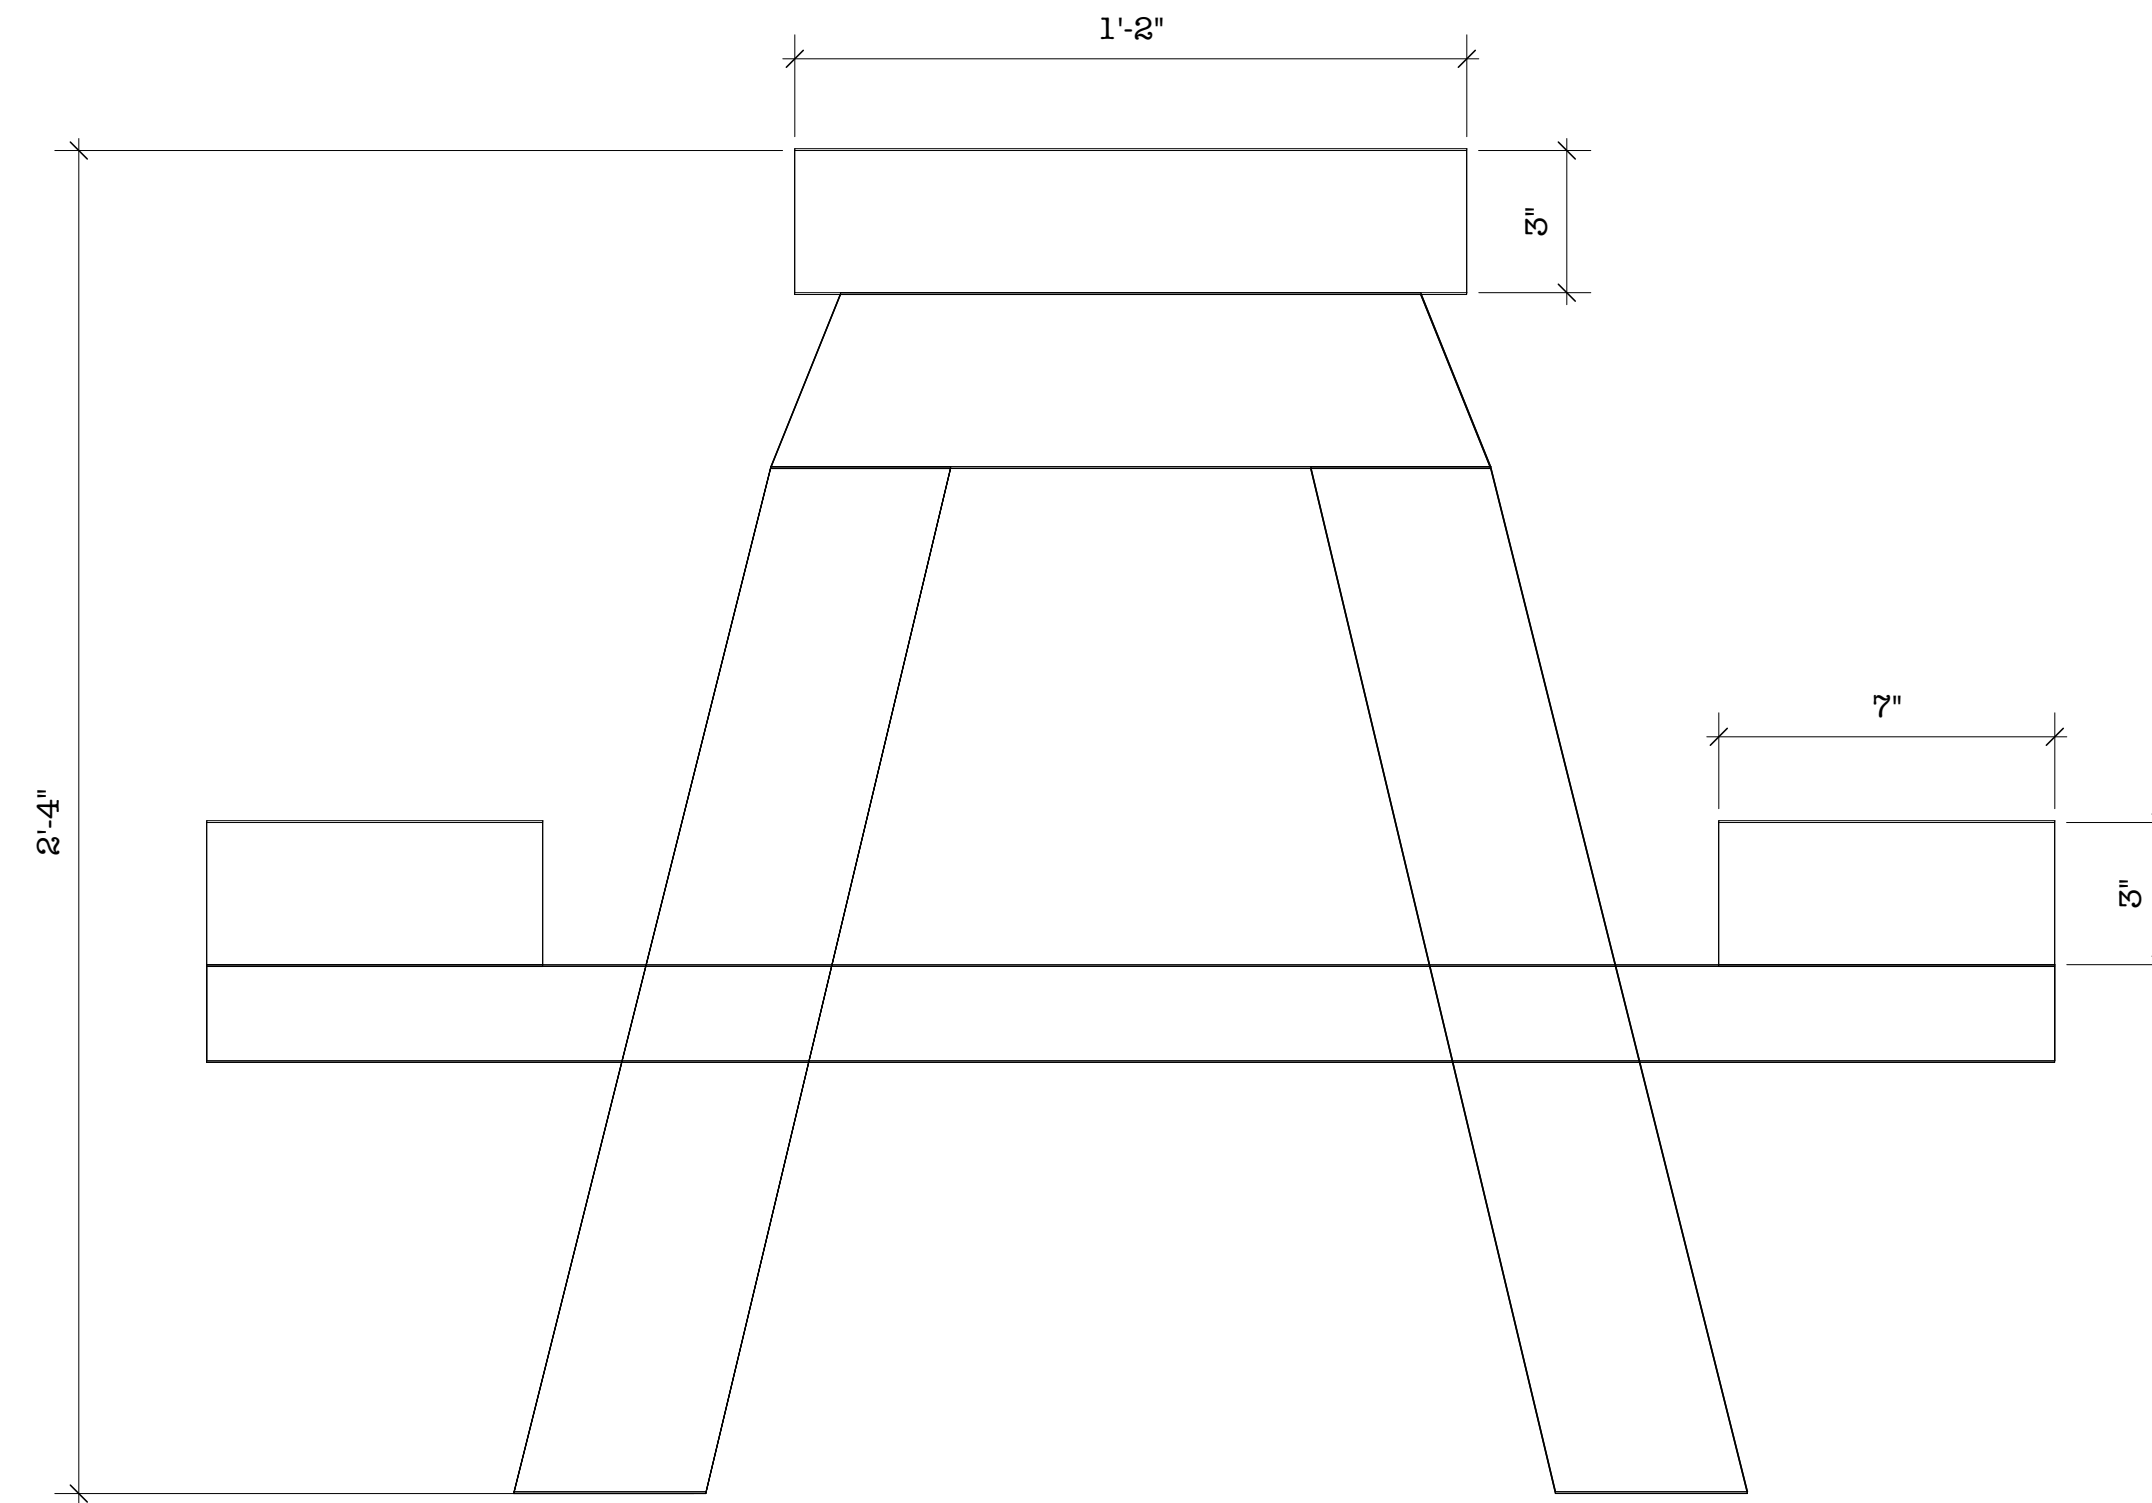

3 Front
Scale: 3" = 1'-0"

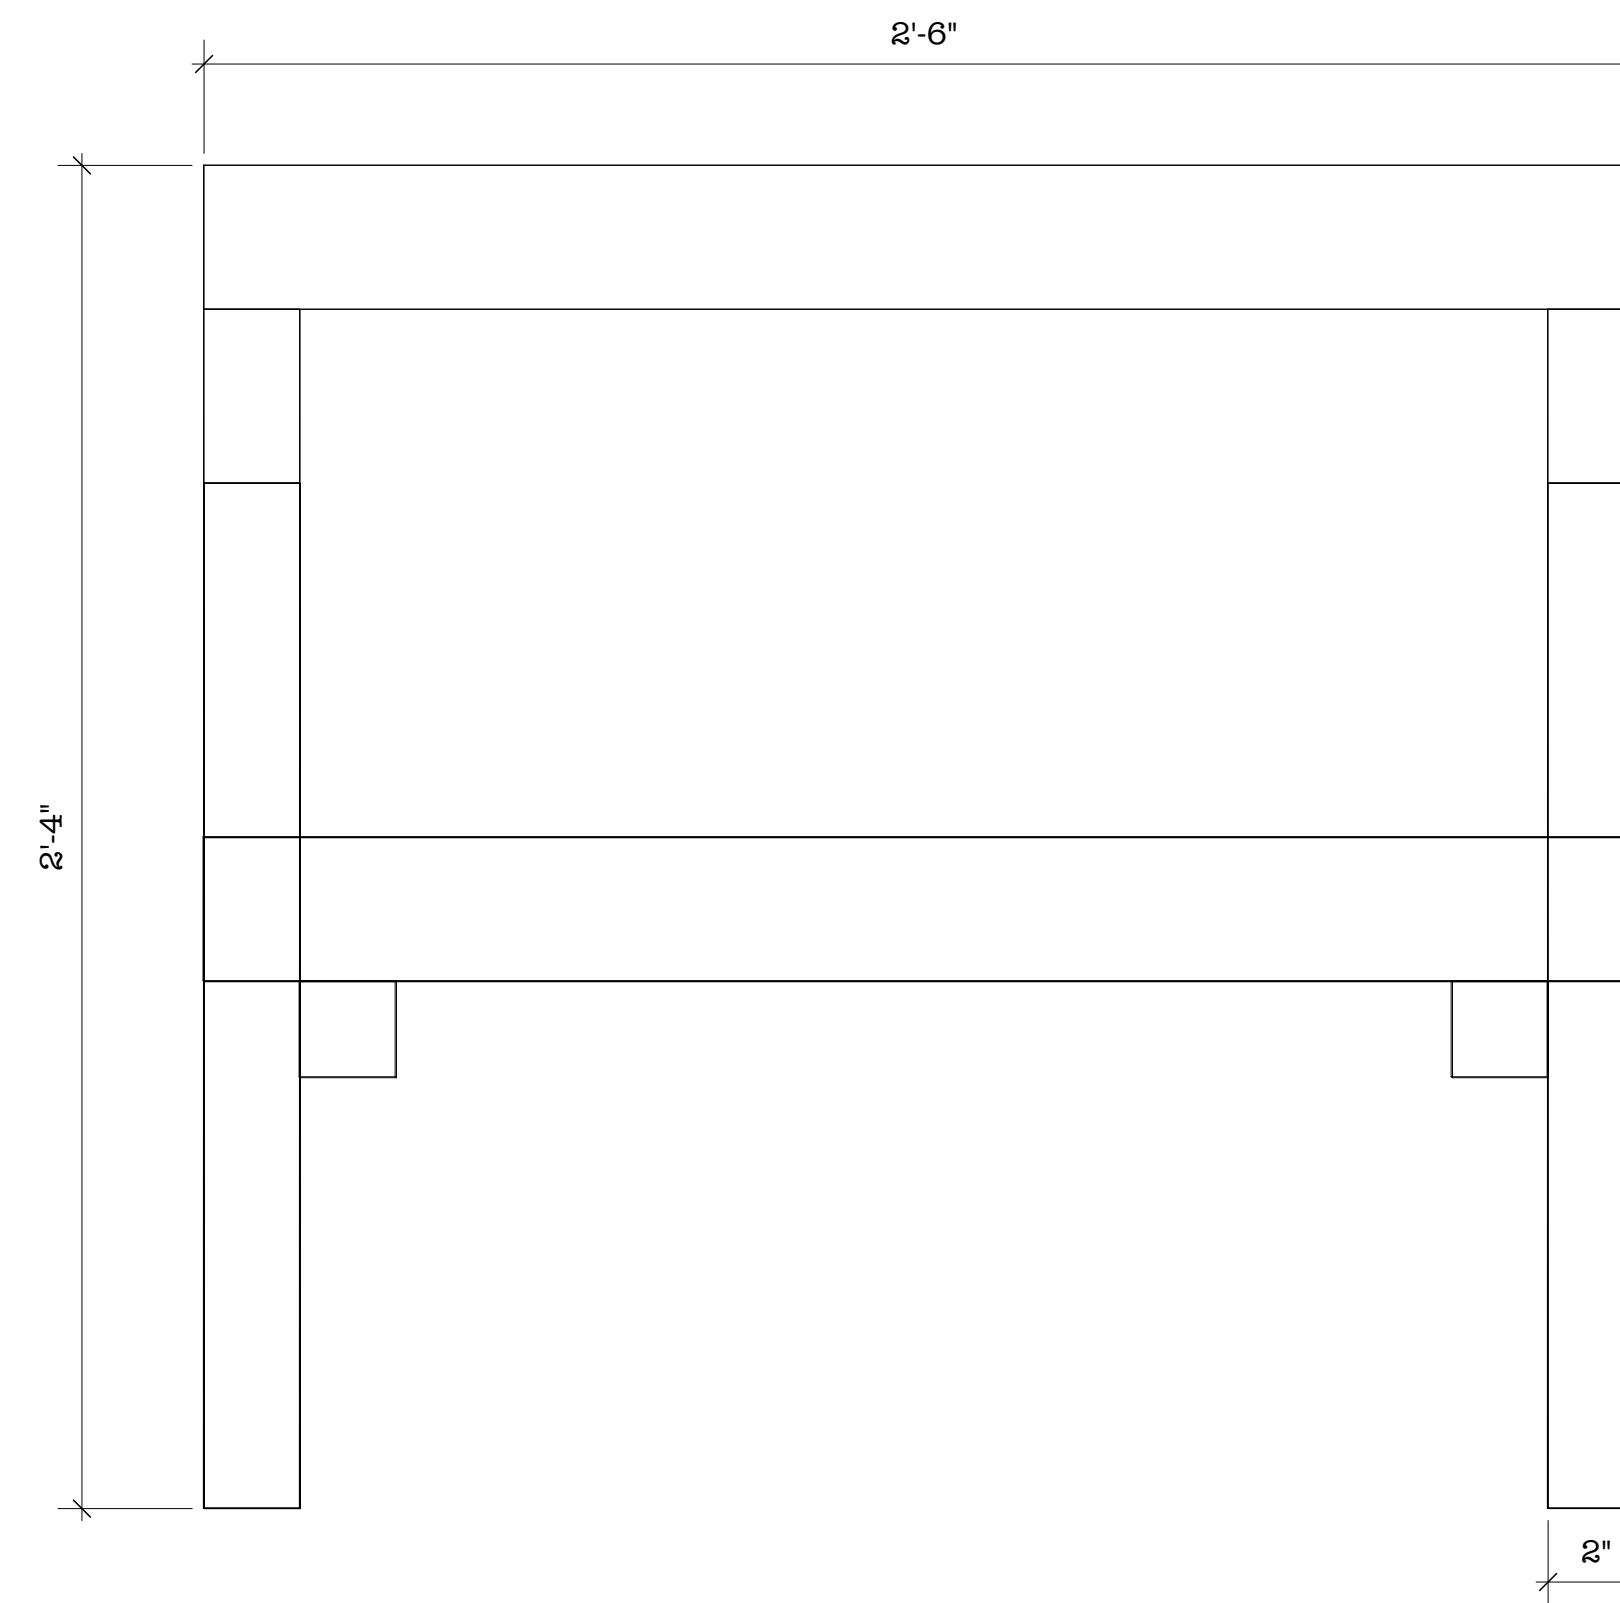

4 Left
Scale: 3" = 1'-0"

Designer/Contact Information: Ron Collins Designs Austin, TX		Drawn By:	Revision Date:
NOTES:			
Project: Master Suite		Producer: Detail-Fuck/Sparking Bench	
Date:		12/16/20	
Scale:		1:4	
Sheet:		<div style="font-size: 2em; font-weight: bold;">[5]</div> <div style="font-size: 0.8em;">OF</div> <div style="font-size: 3em; font-weight: bold;">9</div>	



1 Bedroom
Scale: 1/2" = 1'-0"



2 Closet
Scale: 1/2" = 1'-0"



3 Ensuite
Scale: 1/2" = 1'-0"



4 Bathroom Opposite
Scale: 1/2" = 1'-0"

Designer/Contact Information:
Ron Collins Designs
Austin, TX

Drawn By:
Revision Date:

NOTES:
Camera Location and Lighting
Levels on Sheet 8.

Project:
Master Suite

Producer:
Renderwork

Purpose:


Date:
12/16/20

Scale:
1:1

Sheet:
[6]
OF
9



1 Sling View
Scale: 3/4" = 1'-0"

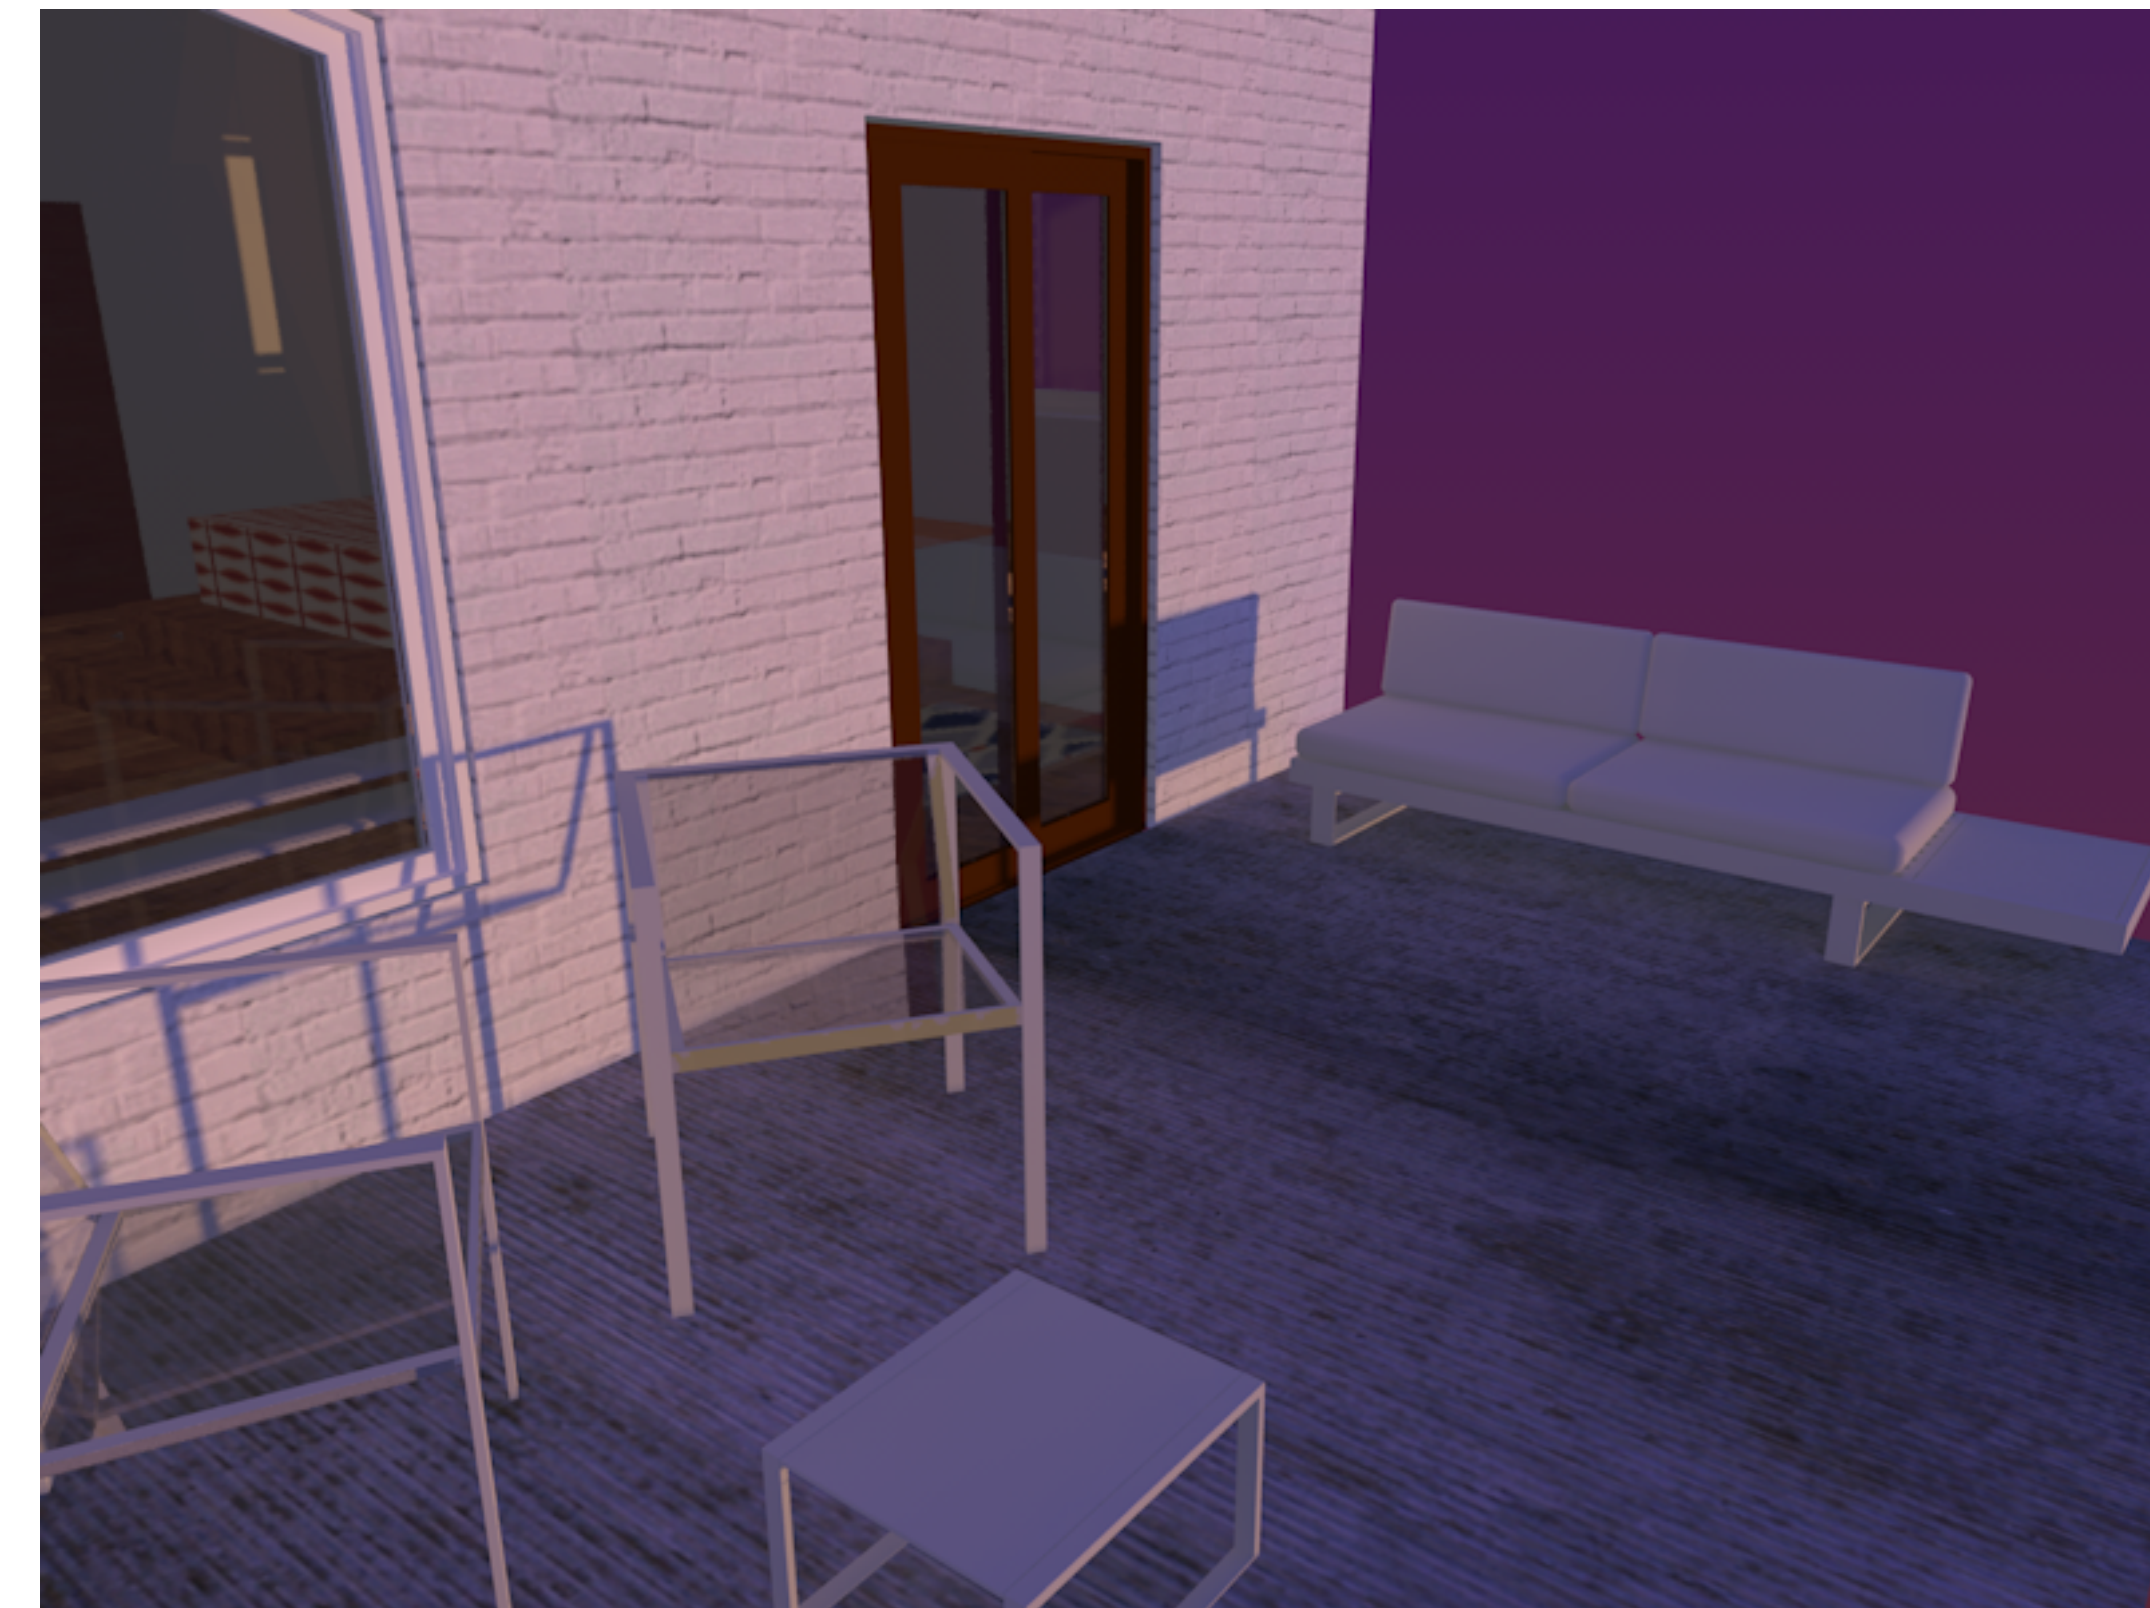

2 Patio
Scale: 1/2" = 1'-0"

Designer/Contact Information:
Ron Collins Designs
Austin, TX

Drawn By:
Revision Date:

NOTES:
Camera Location and Lighting
Levels on Sheet 8.


Project:
Master Suite

Producer:
Renderwork Cont.

Date:
12/17/20

Scale:
1:24

Sheet:
[7]
OF
9

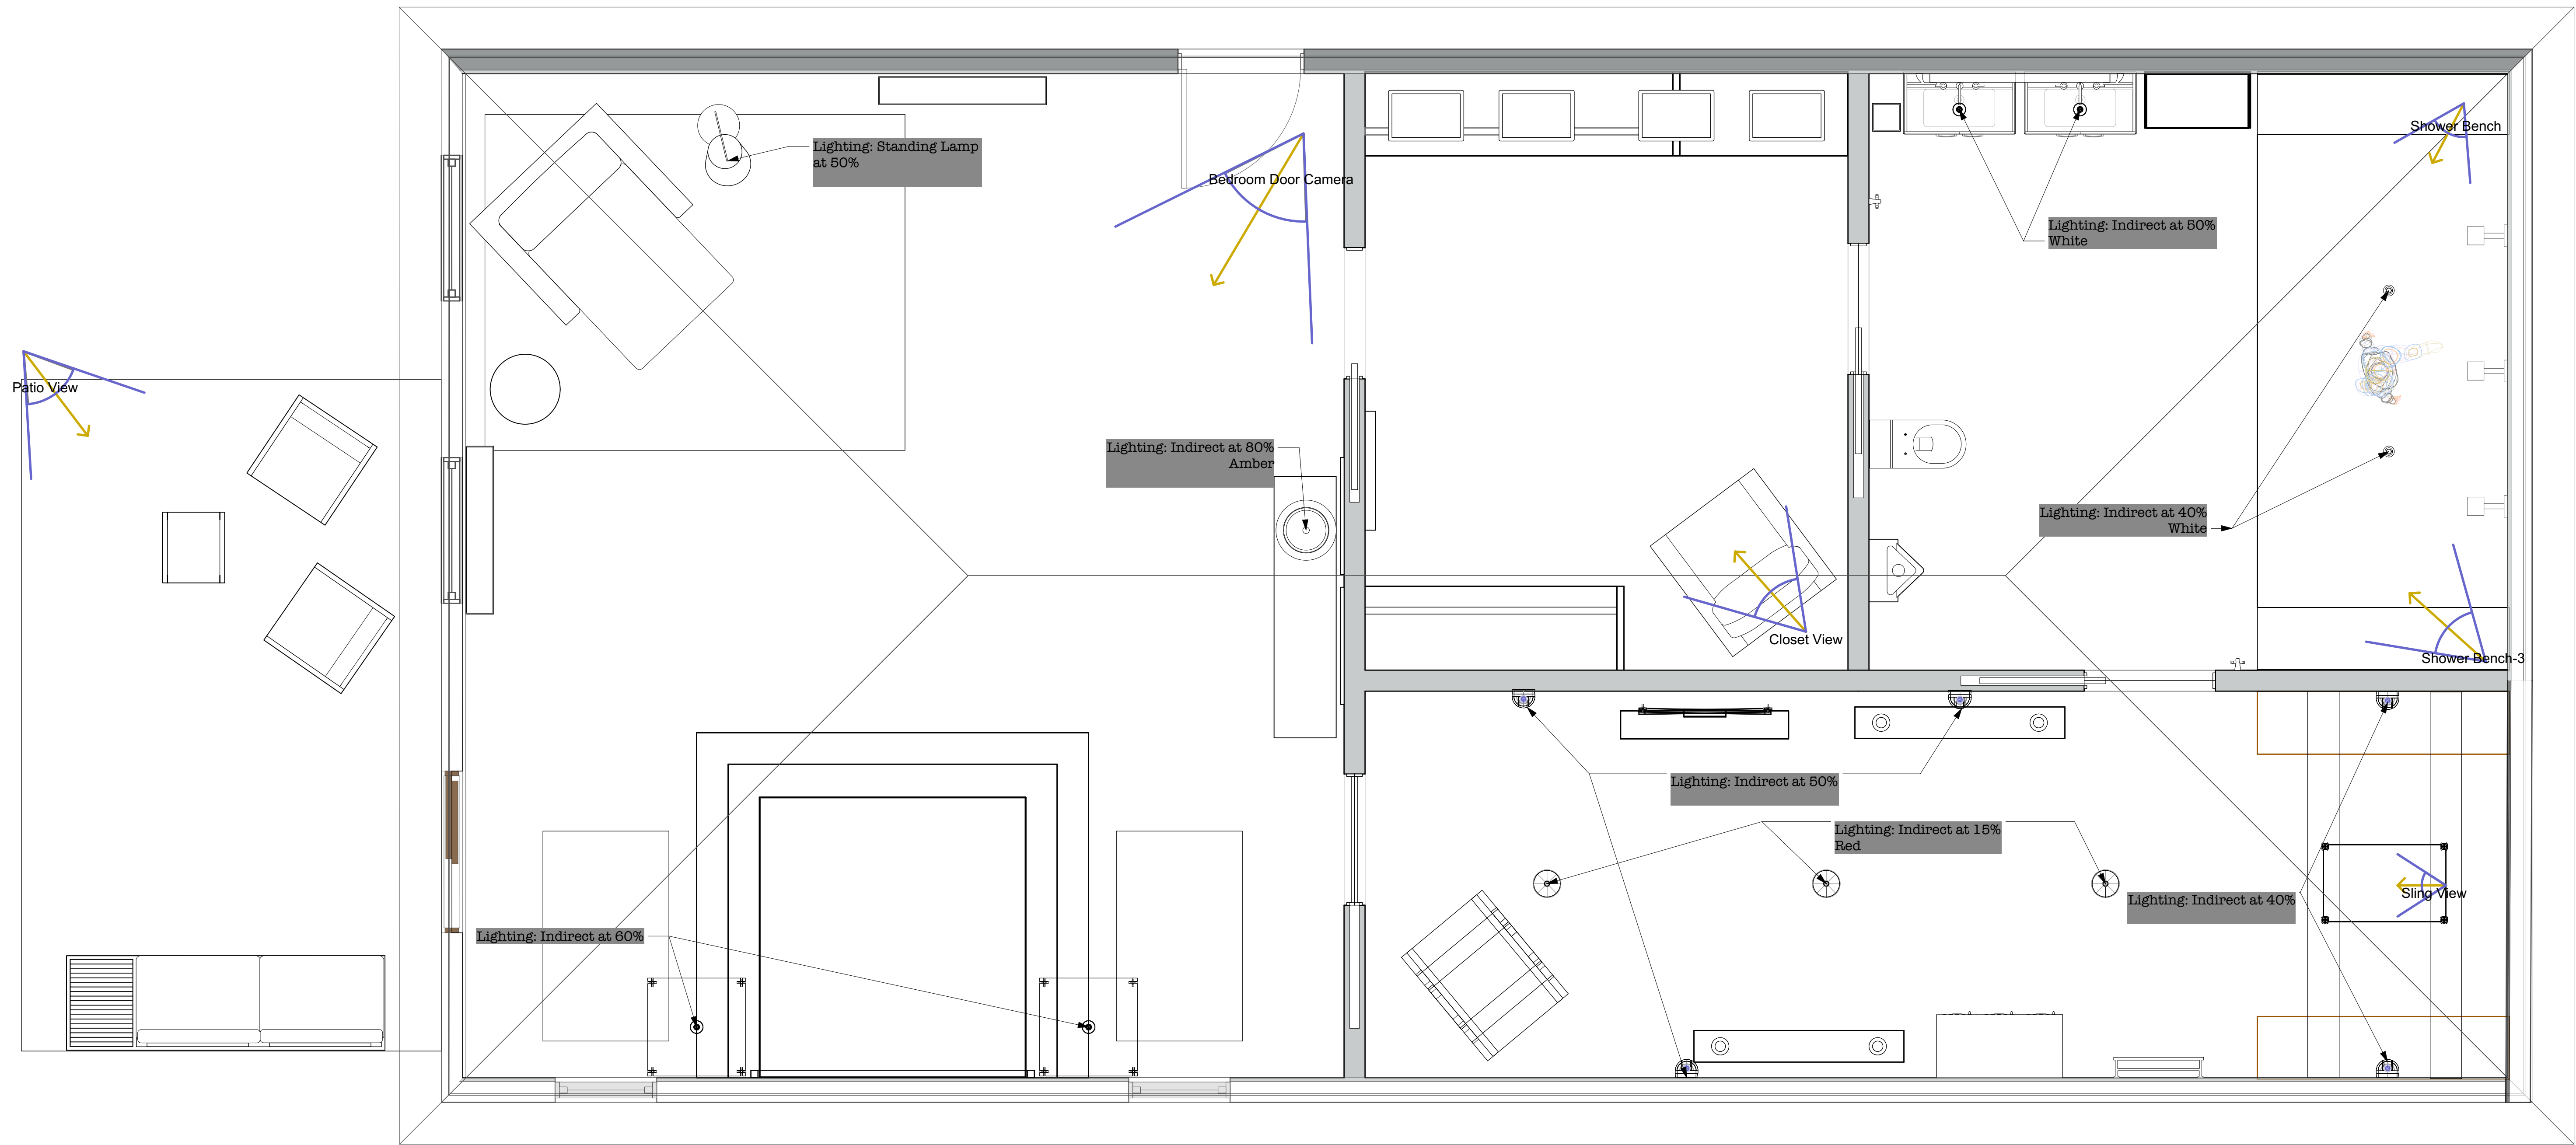

1 Camera and Lighting Plan
 Scale: 1/2" = 1'-0"

Designer/Contact Information:
 Ron Collins Designs
 Austin, TX

Drawn By:
 Revision Date:

NOTES:


Project:
Master Suite

Producer:
Camera and Lighting Plan

Date:
 12/17/20

Scale:
 1:24

Sheet:
[8]
 OF
9

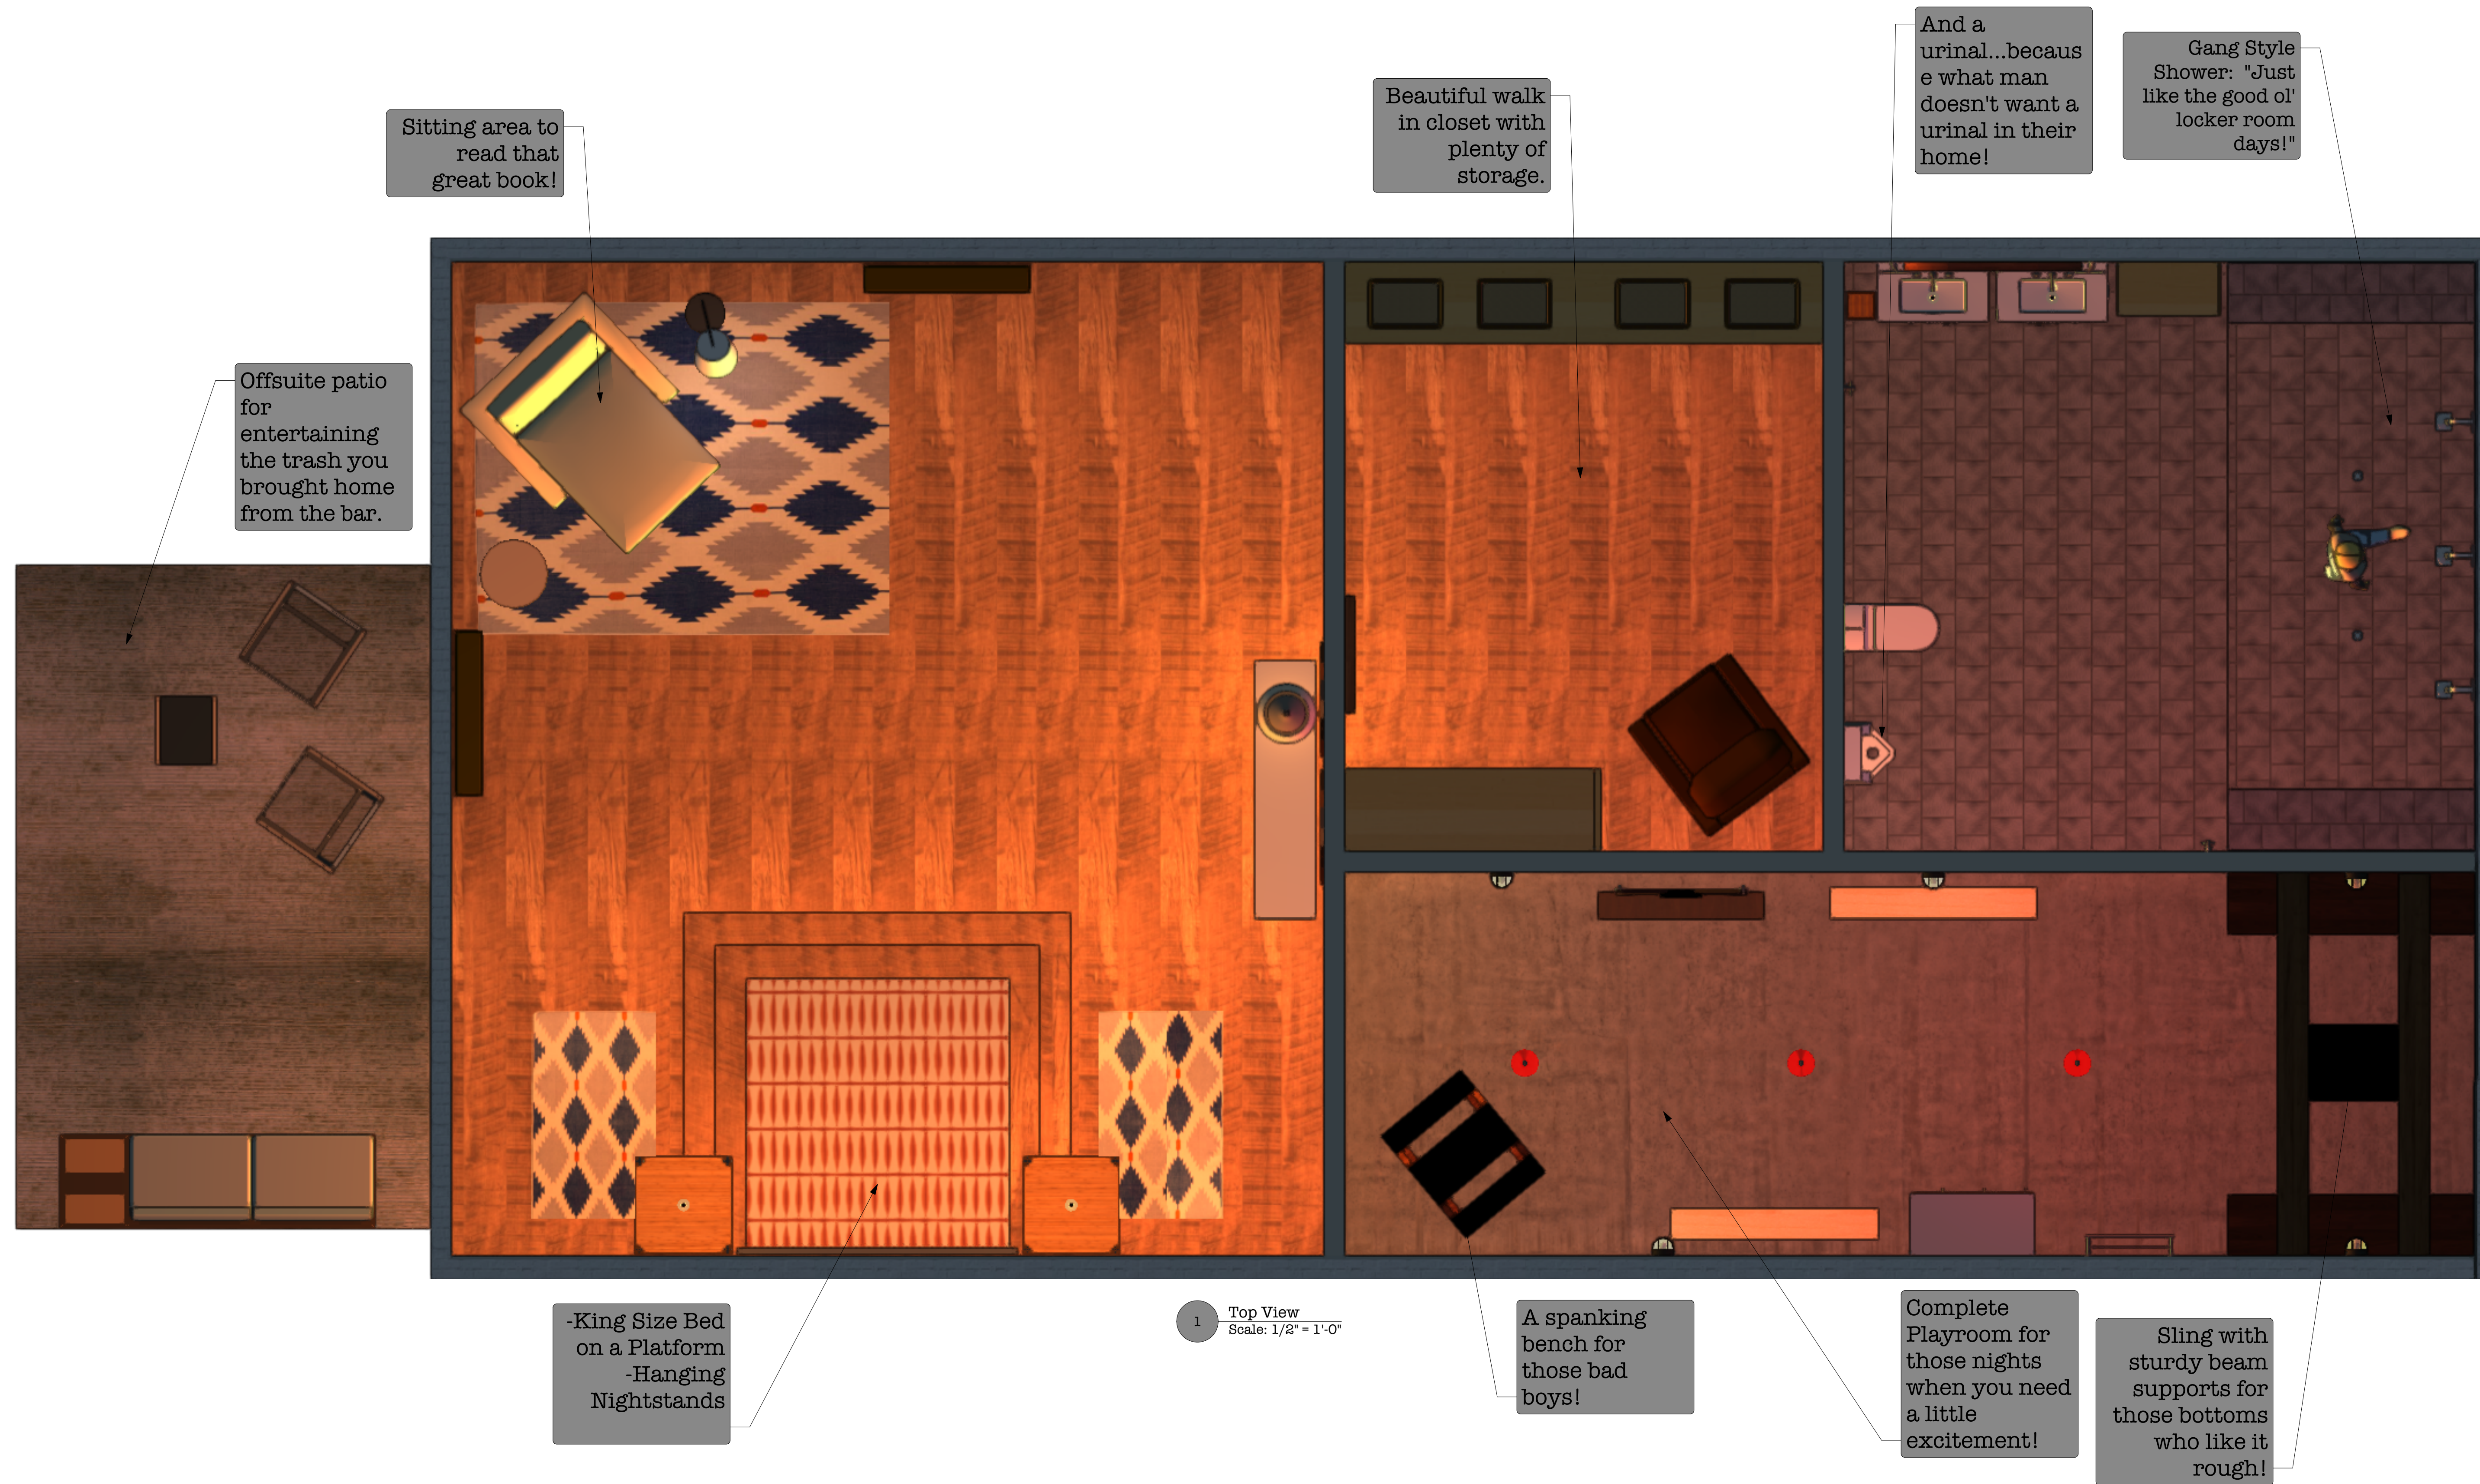

Call for pricing and more information

The Master Suite
for the Master

Pleasurepriceless!

Designer/Contact Information:
Ron Collins Designs
Austin, TX

Drawn By:
Revision Date:

NOTES:

Project: **Master Suite**

Producer: **Top Rendered View**

Date: 12/17/20

Scale: 1:24

Sheet: **[9]**
OF
9